





에다함


대구점 인테리어 공사

INTERIOR DRAWINGS

2017. 08. BOQ 도면

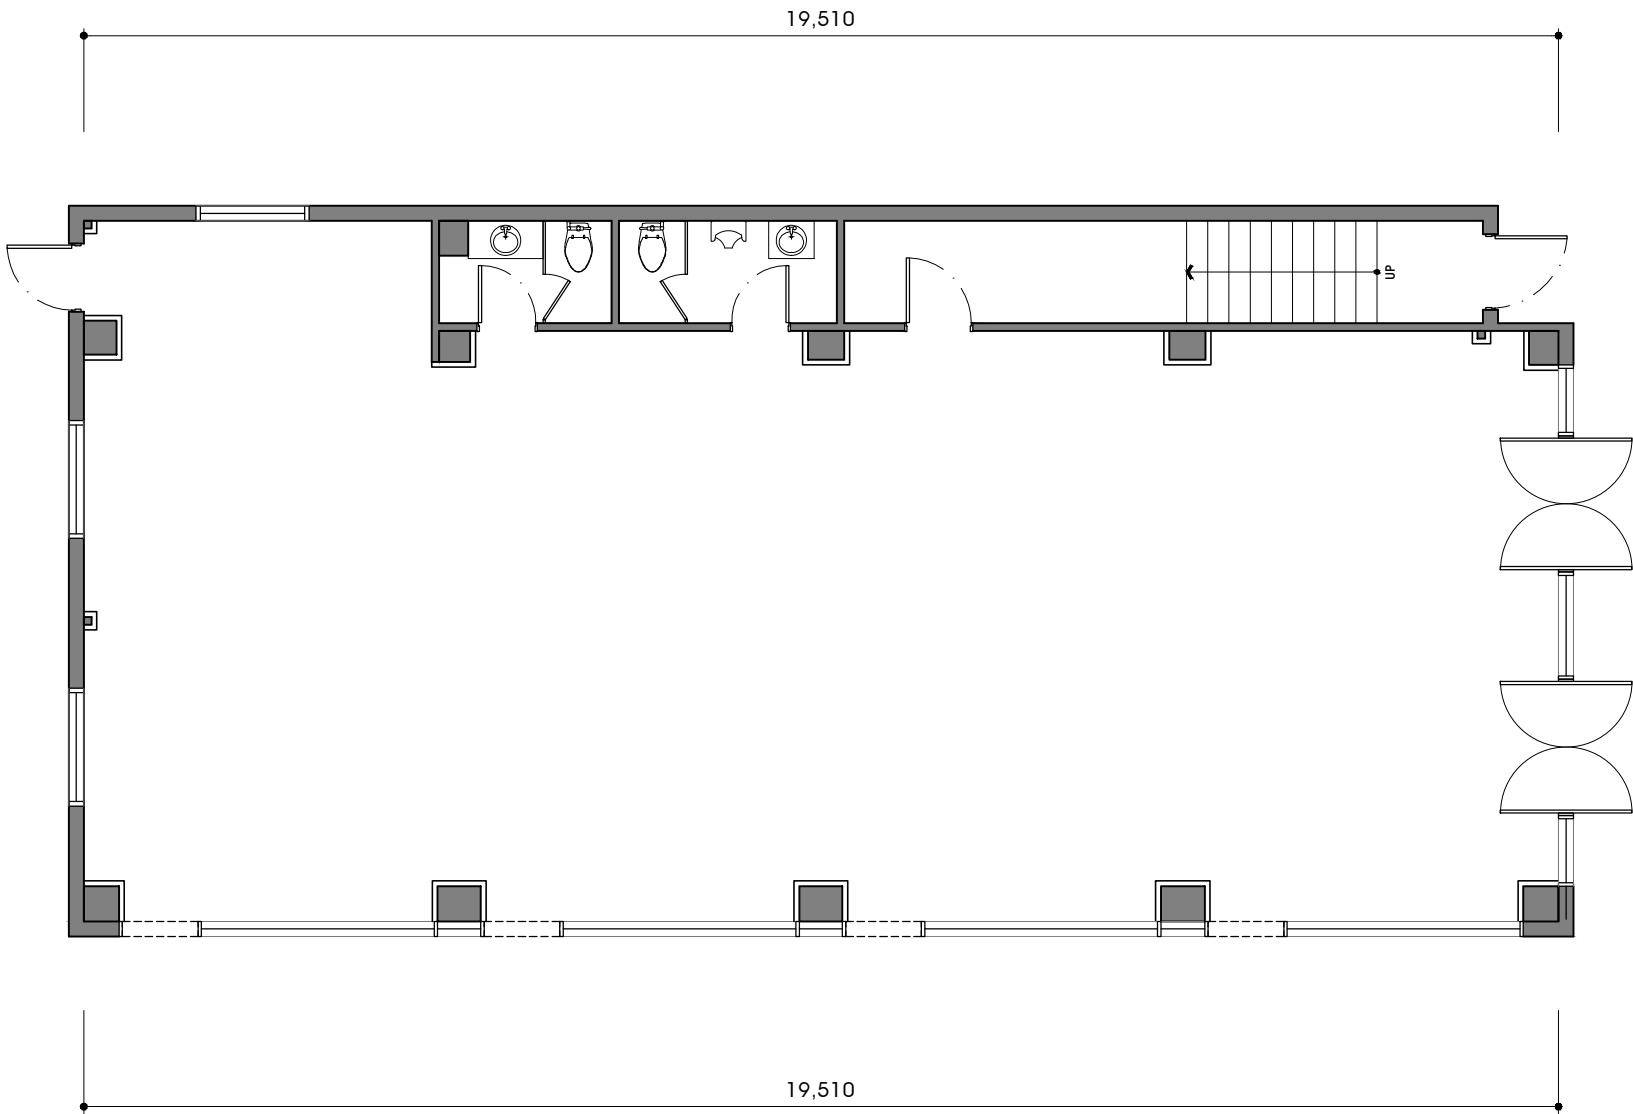


PROJECT TITLE	
	
PROJECT	
예다함 _ 대구	
ARCHITECTURE DESIGN	
INTERIOR ARCHITECTURE	
NOTE	
REF.DWG.NO.	
REVISIONS	
△	
△	
△	
△	
△	
KEY PLAN	
DESIGNDE BY	
DRAWING BY	
CHECKED BY	
CHECKED BY	
APPROVED BY	
NAME OF DRAWING	
FLOOR PLAN	
SCALE	
A1 : 1/100 A3 : 1/100	
DATE	
2017. 08	
FILE NAME	
DRAWING NO.	
FLO1	
SHEET NO.	
001	
INTERIOR ARCHITECTURE	

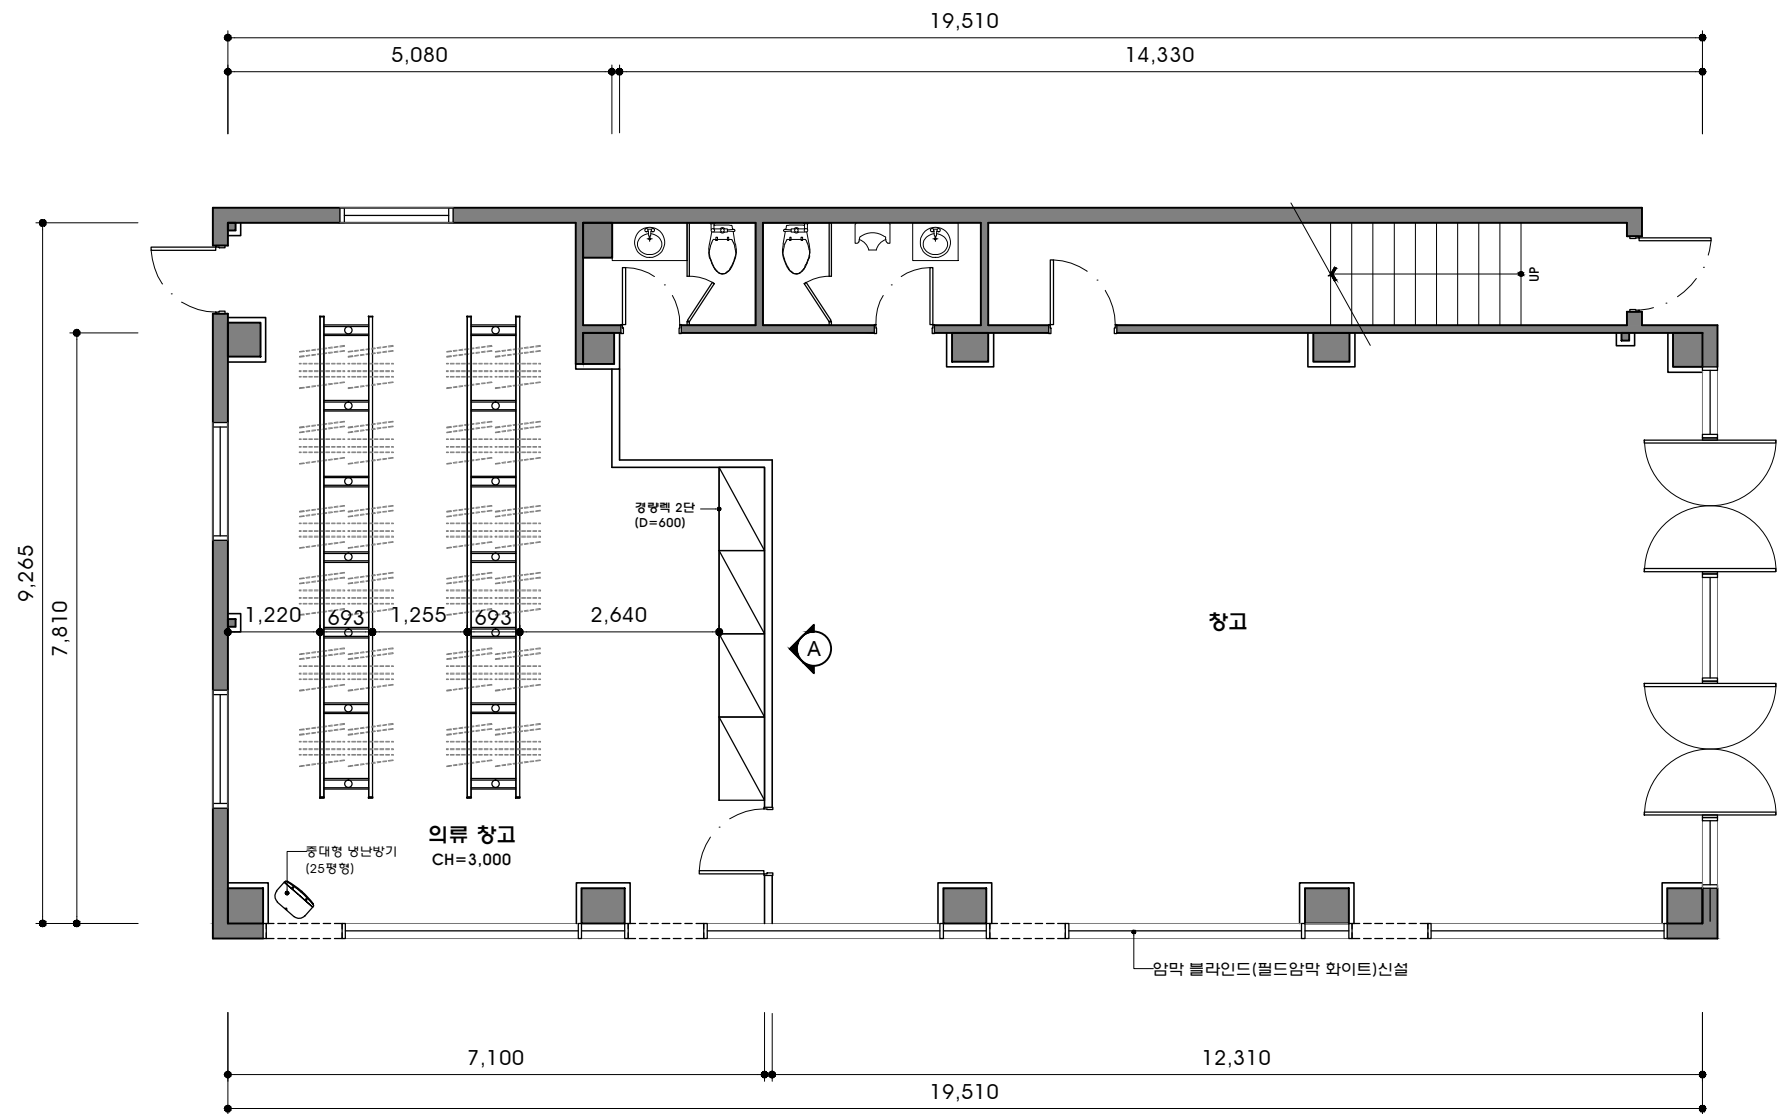

블라인드 : 권우창 안수천 (010-9551-0611)

PROJECT TITLE	예다함
PROJECT	예다함 _ 대구
ARCHITECTURE DESIGN	
INTERIOR ARCHITECTURE	
NOTE	
REF.DWG.NO.	
REVISIONS	
DESIGNED BY	
DRAWING BY	
CHECKED BY	
CHECKED BY	
APPROVED BY	
NAME OF DRAWING	FLOOR PLAN
SCALE	A1 : 1/100 A3 : 1/100
DATE	2017. 08
FILE NAME	
DRAWING NO.	FL02
SHEET NO.	002
INTERIOR ARCHITECTURE	

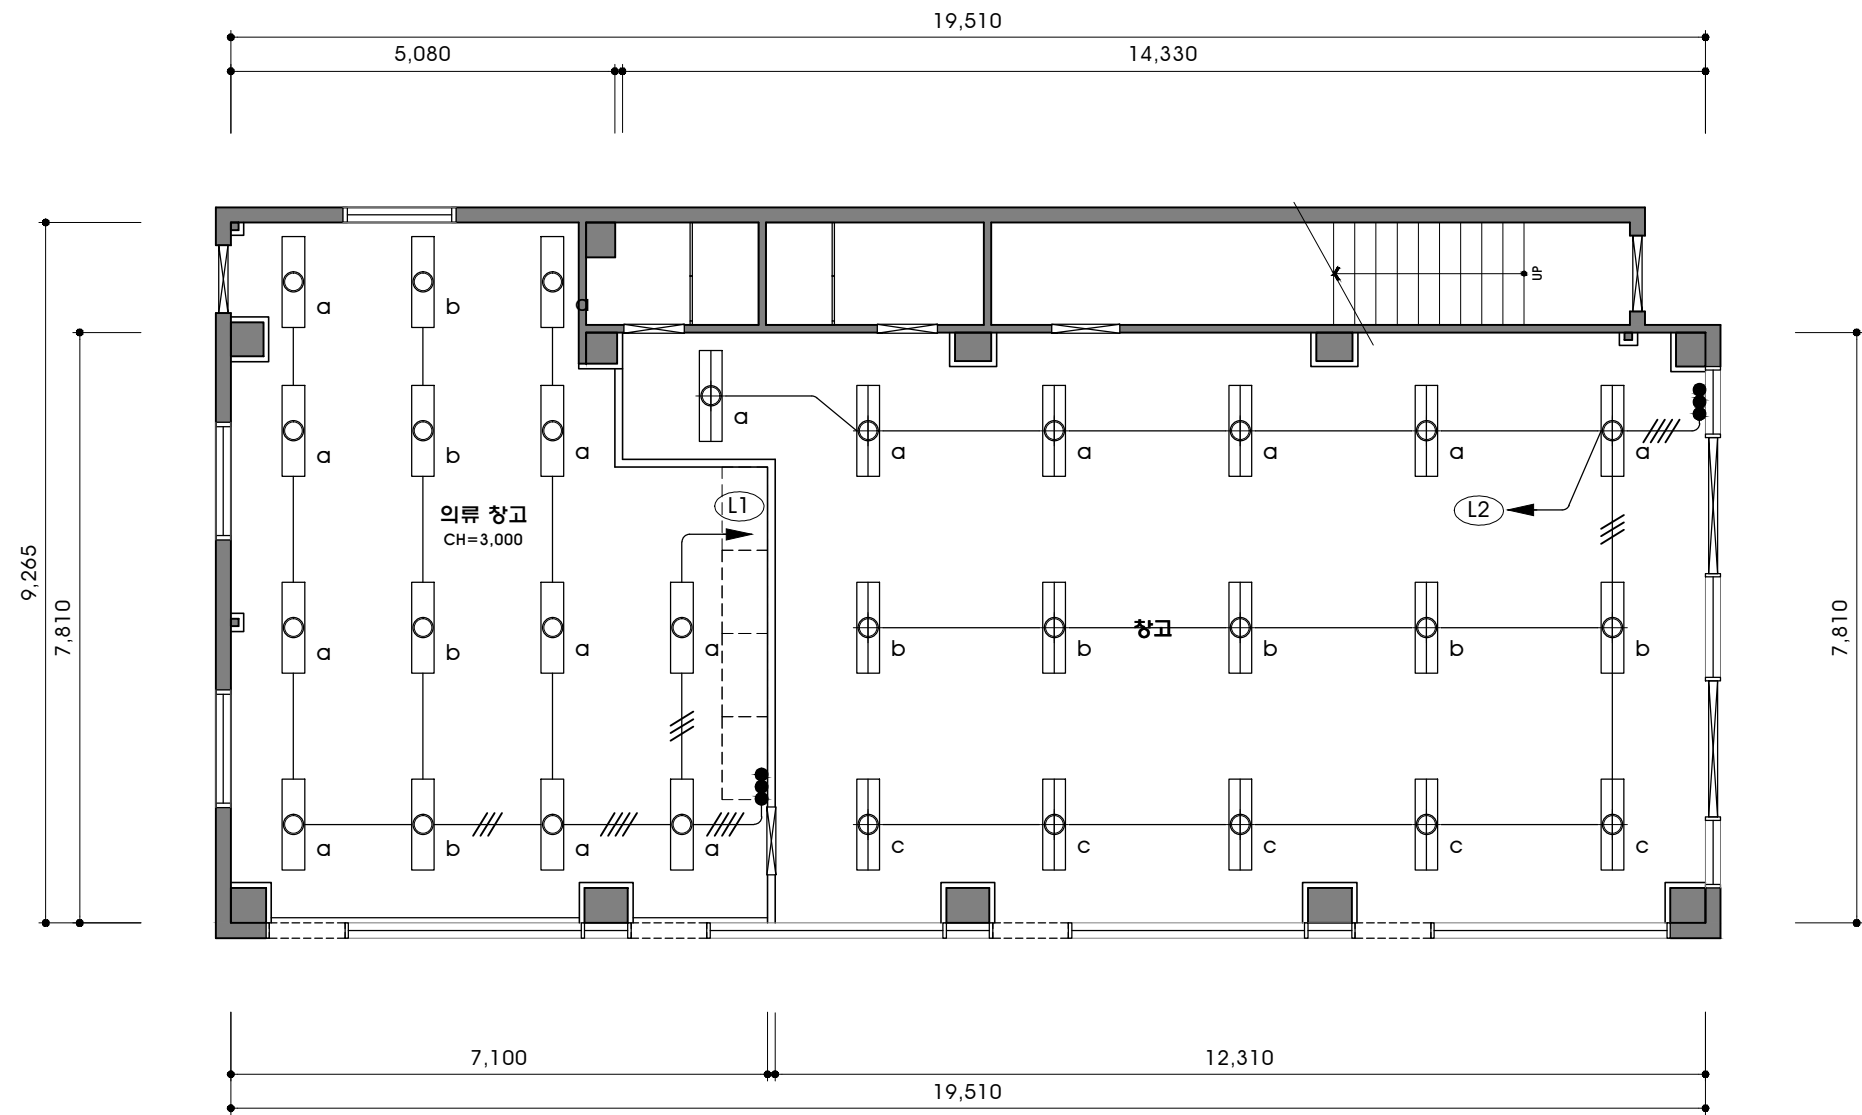

LEGEND

심볼	명칭	수량
	슬림 매입개방 형광등(32W x 2)	16
	노출직부 슬림 매입개방 형광등 (32W x 2)	14

PROJECT TITLE

PROJECT
예다함 _ 대구

ARCHITECTURE DESIGN

INTERIOR ARCHITECTURE

NOTE

REF.DWG.NO.

REVISIONS

△	
△	
△	
△	
△	

KEY PLAN

DESIGNED BY

DRAWING BY

CHECKED BY

CHECKED BY

APPROVED BY

NAME OF DRAWING
전등설비 평면도

SCALE
A1 : 1/100 A3 : 1/100


DATE
2017. 08

FILE NAME

DRAWING NO.
CL01

SHEET NO.
003

INTERIOR ARCHITECTURE

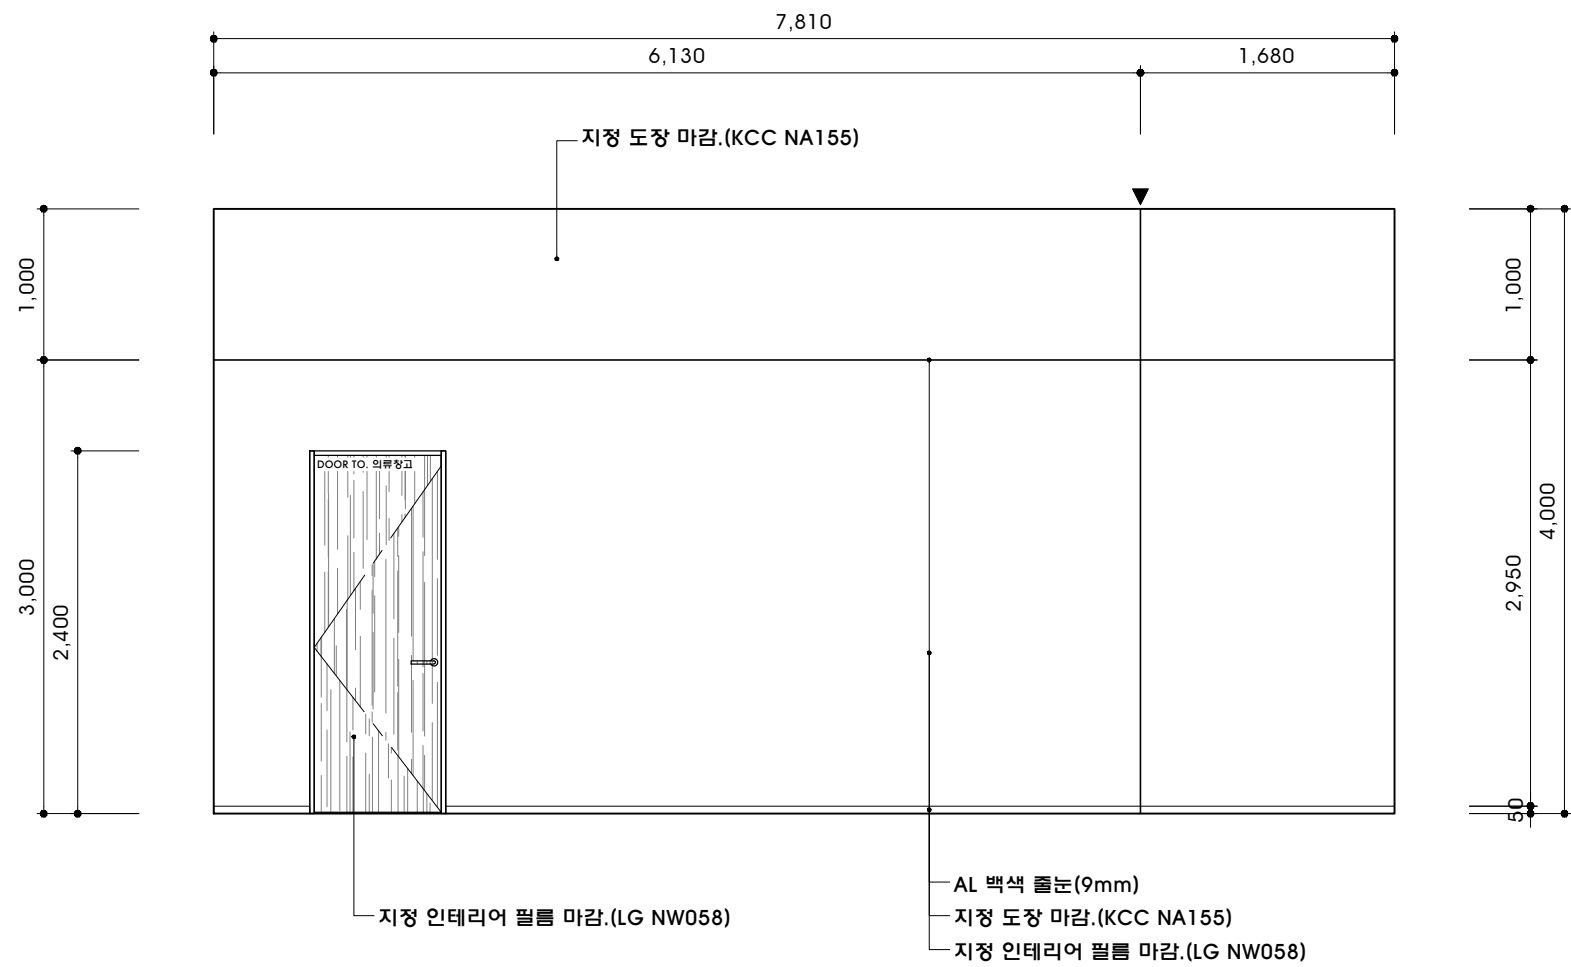

PROJECT TITLE



PROJECT

ARCHITECTURE DESIGN

 
INTERIOR ARCHITECTURE

NOTE

CH=2,690MM

REF.DWG.NO.

REVISIONS



KEY PLAN

DESIGNED BY

DRAWING BY

CHECKED BY

CHECKED BY

APPROVED BY

NAME OF DRAWING

1층 창고
ELEVATION - A

SCALE

A3 : 1/50 A4 : 1/70

DATE

2017. 08

FILE NAME

DRAWING NO.

EL - 001

SHEET NO.


004

INTERIOR ARCHITECTURE

1 ELEVATION - A


SCALE

A3 : 1/50 A4 : 1/70

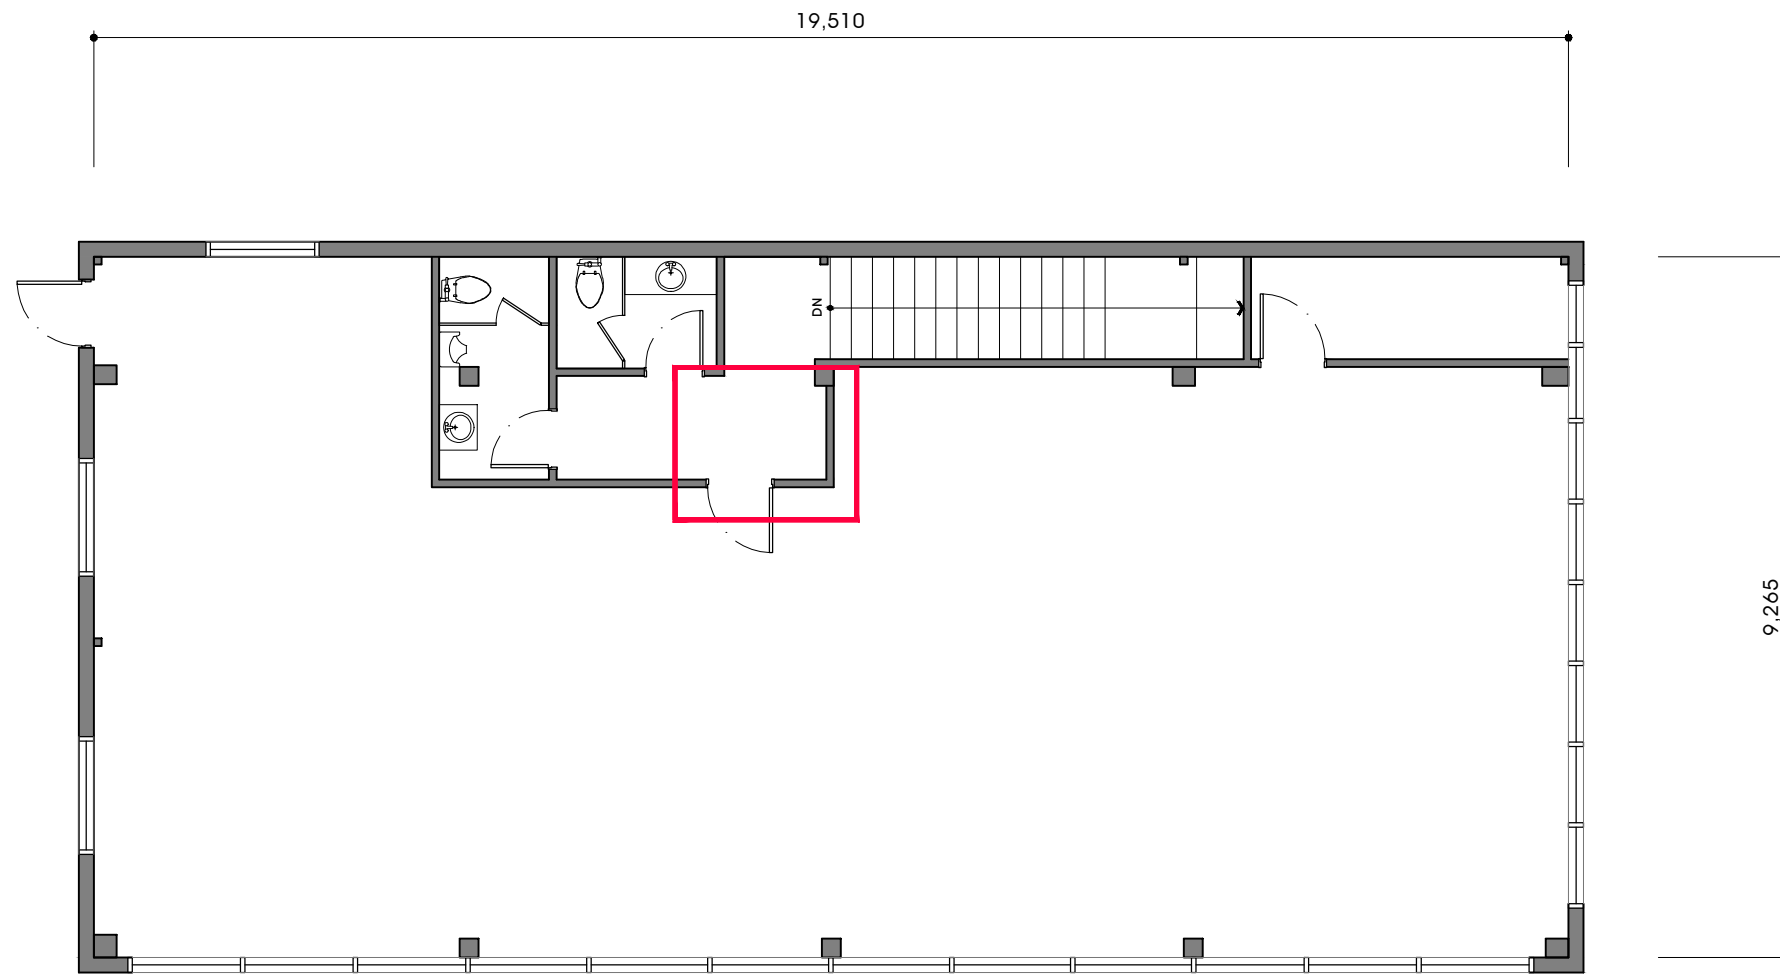


철거 및 바닥/천정 보수

PROJECT TITLE	
예다함	
PROJECT	
예다함 _ 대구	
ARCHITECTURE DESIGN	
INTERIOR ARCHITECTURE	
NOTE	
REF.DWG.NO.	
REVISIONS	
△	
△	
△	
△	
△	
KEY PLAN	
DESIGNED BY	
DRAWING BY	
CHECKED BY	
CHECKED BY	
APPROVED BY	
NAME OF DRAWING	
FLOOR PLAN	
SCALE	
A1 : 1/100 A3 : 1/100	
DATE	
2017. 08	
FILE NAME	
DRAWING NO.	
FLO1	
SHEET NO.	
005	
INTERIOR ARCHITECTURE	

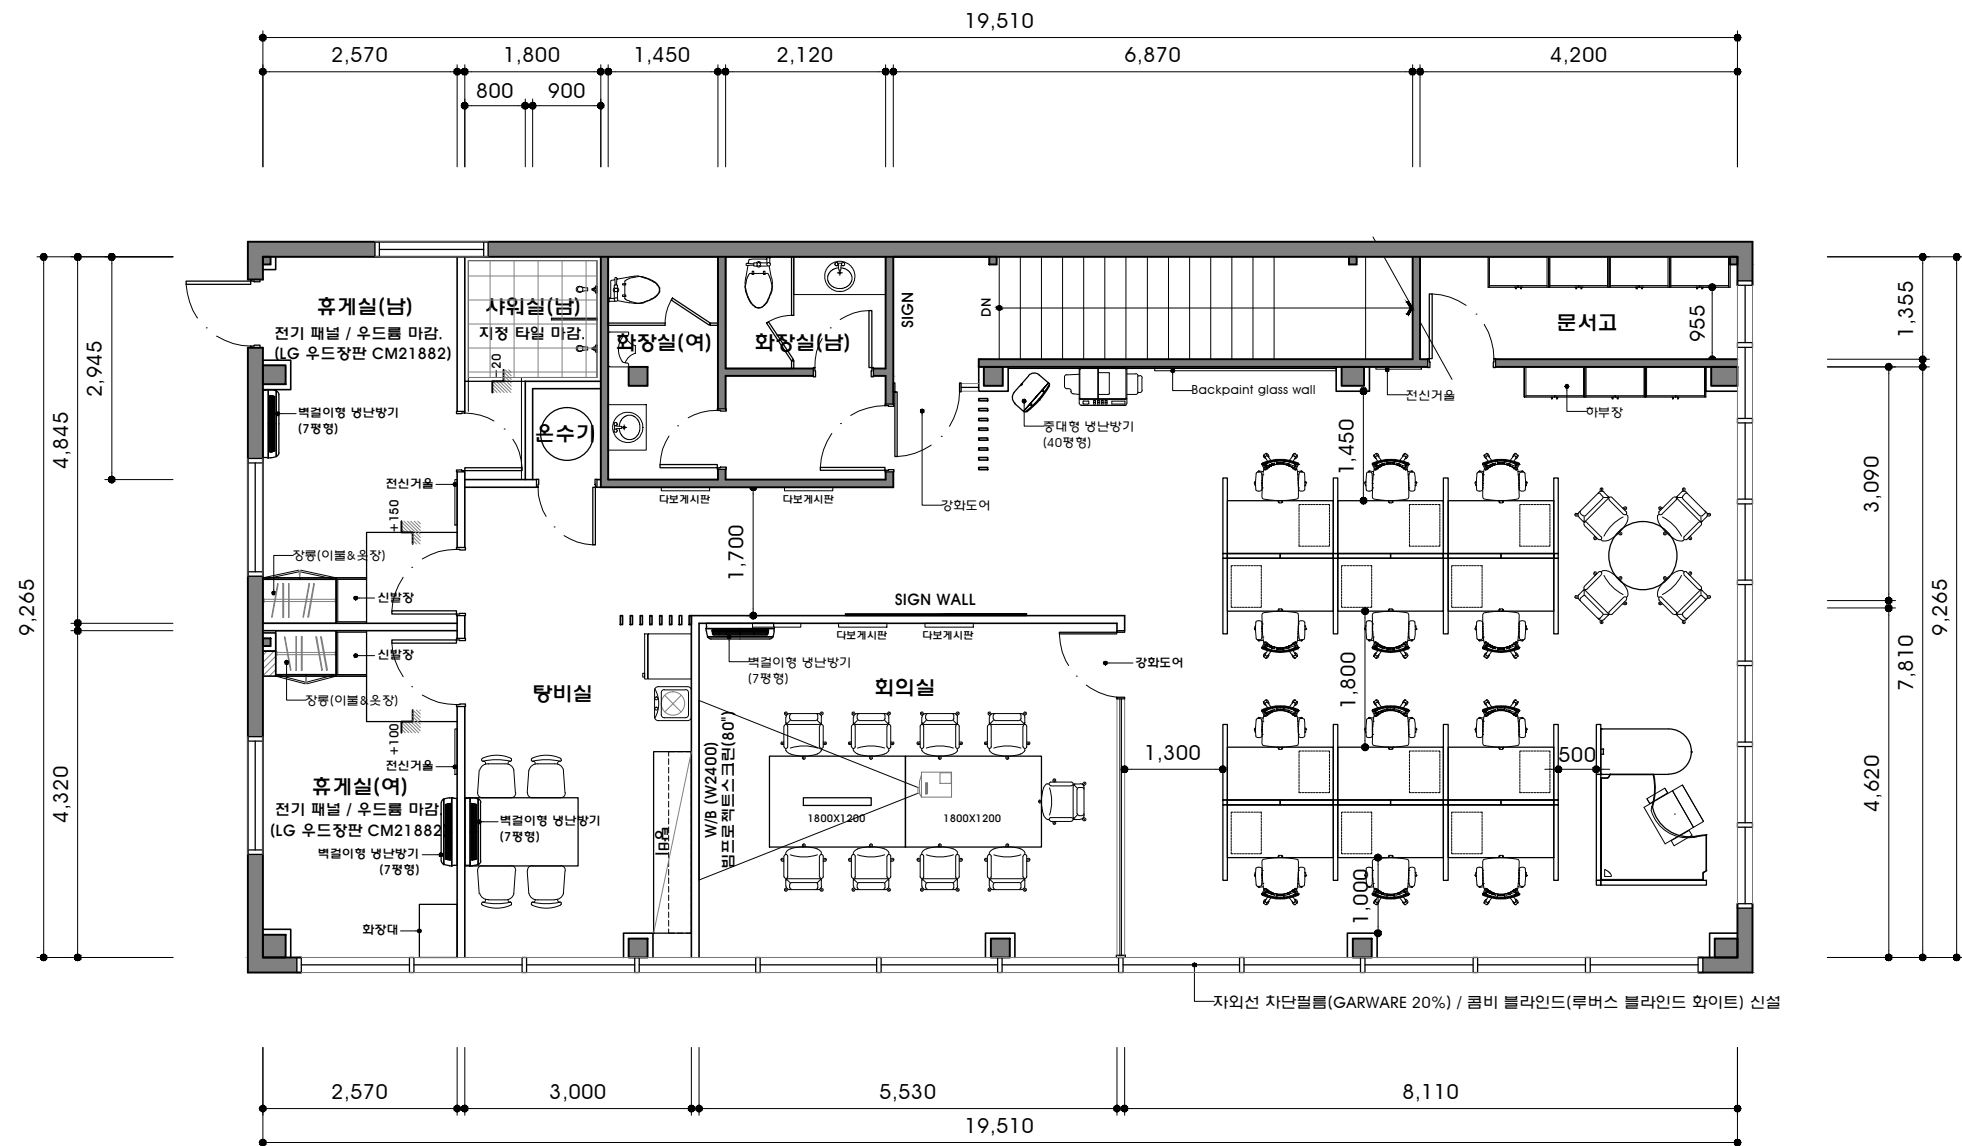

블라인드 : 권우창 안수천 (010-9551-0611)


PROJECT TITLE		
PROJECT	예다함 _ 대구	
ARCHITECTURE DESIGN		
INTERIOR ARCHITECTURE		
NOTE		
REF.DWG.NO.		
REVISIONS		
KEY PLAN		
DESIGNED BY		
DRAWING BY		
CHECKED BY		
CHECKED BY		
APPROVED BY		
NAME OF DRAWING	FLOOR PLAN	
SCALE	A1 : 1/100 A3 : 1/100	
DATE	2017. 08	
FILE NAME		
DRAWING NO.	FL02	
SHEET NO.	006	
INTERIOR ARCHITECTURE		

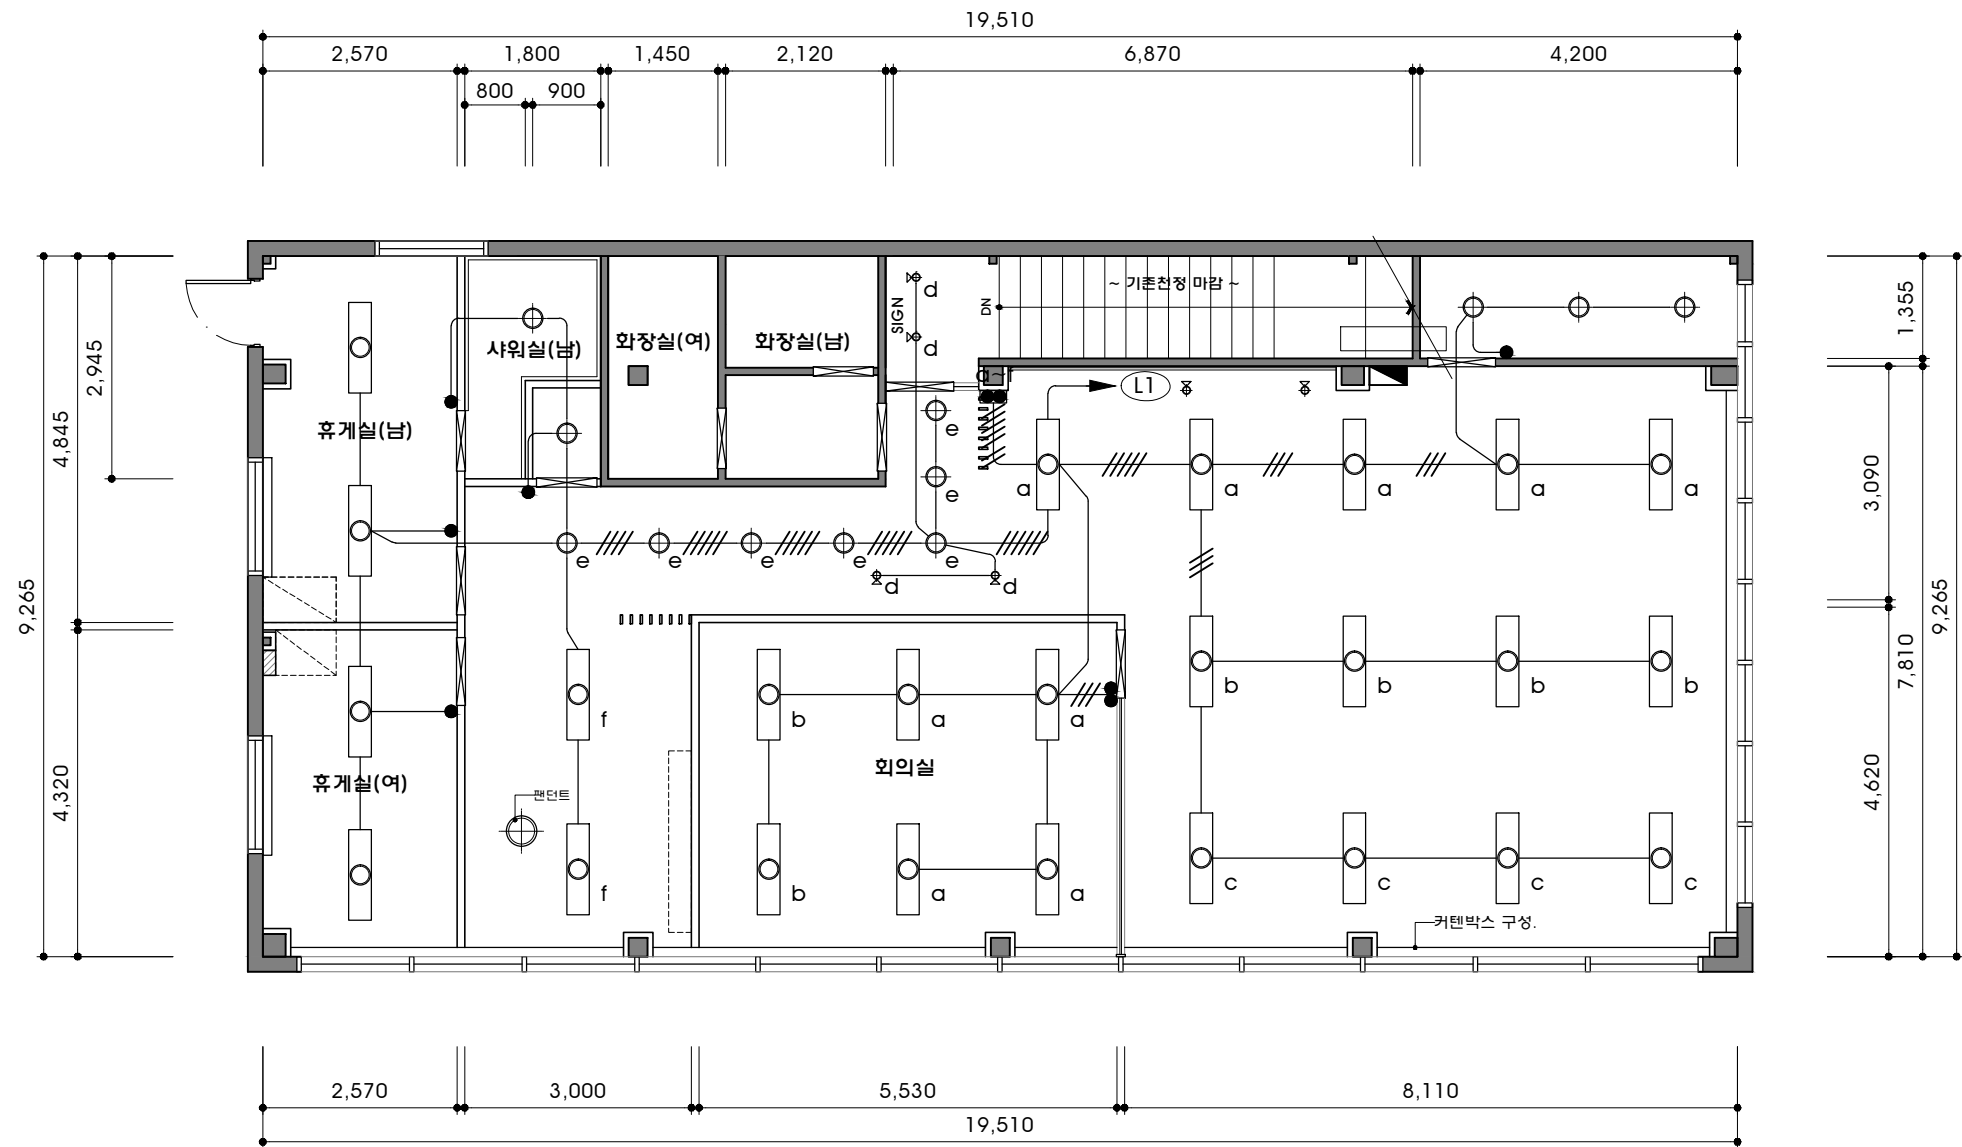


LEGEND		
심볼	명칭	수량
	슬립 매입개방 형광등(32W x 2)	25
	다운라이트 6W LED 20W (샤워실·방수형)	12
	팬던트	1
	알로겐 (MR LED 6W)	6

※ 화장실 등기구 재사용

PROJECT TITLE	
PROJECT	예다함 _ 대구
ARCHITECTURE DESIGN	
INTERIOR ARCHITECTURE	
NOTE	
REF.DWG.NO.	
REVISIONS	
DESIGNED BY	
DRAWING BY	
CHECKED BY	
CHECKED BY	
APPROVED BY	
NAME OF DRAWING	전등설비 평면도
SCALE	A1 : 1/100 A3 : 1/100
DATE	2017. 08
FILE NAME	
DRAWING NO.	CL01
SHEET NO.	007
INTERIOR ARCHITECTURE	

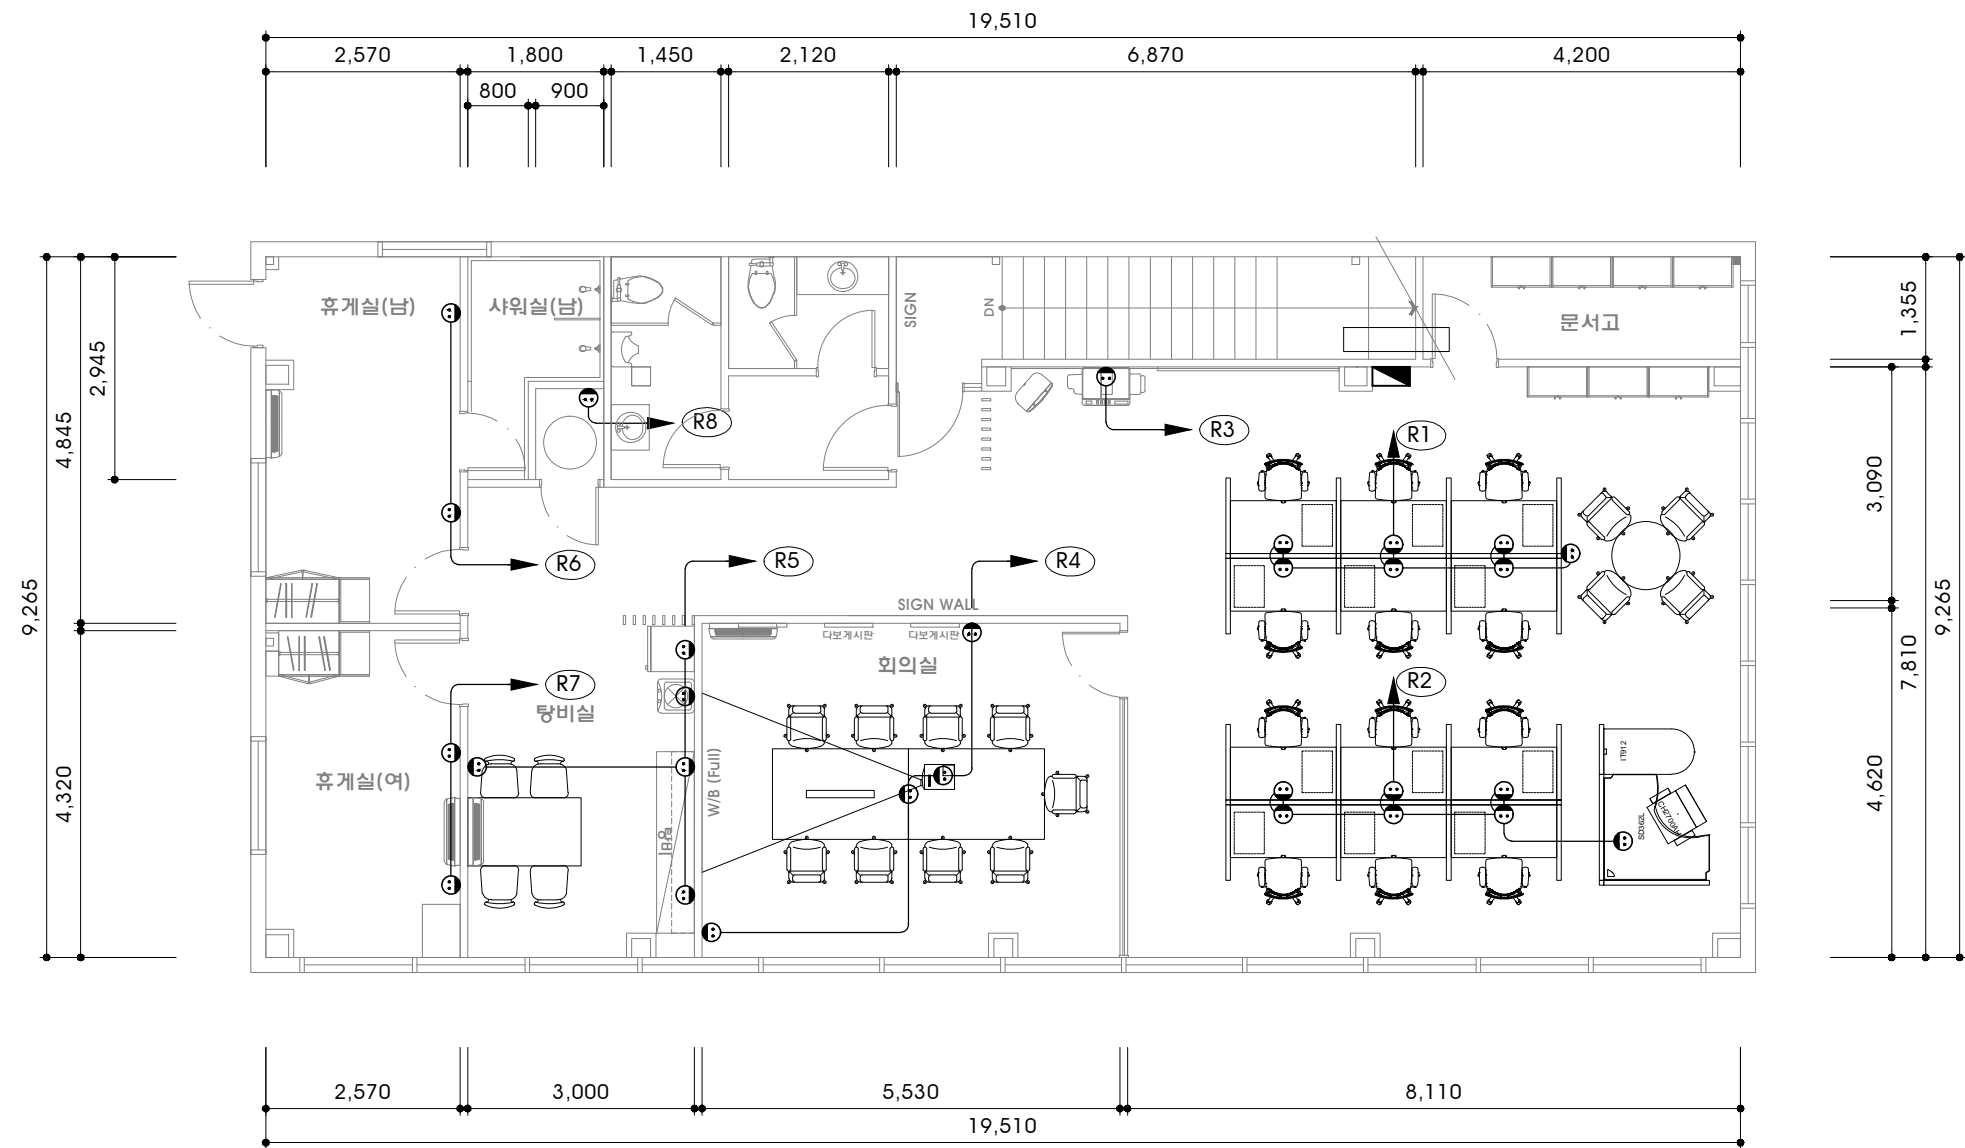

PROJECT TITLE		
PROJECT	예다함 _ 대구	
ARCHITECTURE DESIGN		
INTERIOR ARCHITECTURE		
NOTE		
REF.DWG.NO.		
REVISIONS		
KEY PLAN		
DESIGNDE BY		
DRAWING BY		
CHECKED BY		
CHECKED BY		
APPROVED BY		
NAME OF DRAWING	전열설비 평면도	
SCALE	A1 : 1/100 A3 : 1/100	
DATE	2017. 08	
FILE NAME		
DRAWING NO.	CL02	
SHEET NO.	008	
INTERIOR ARCHITECTURE		

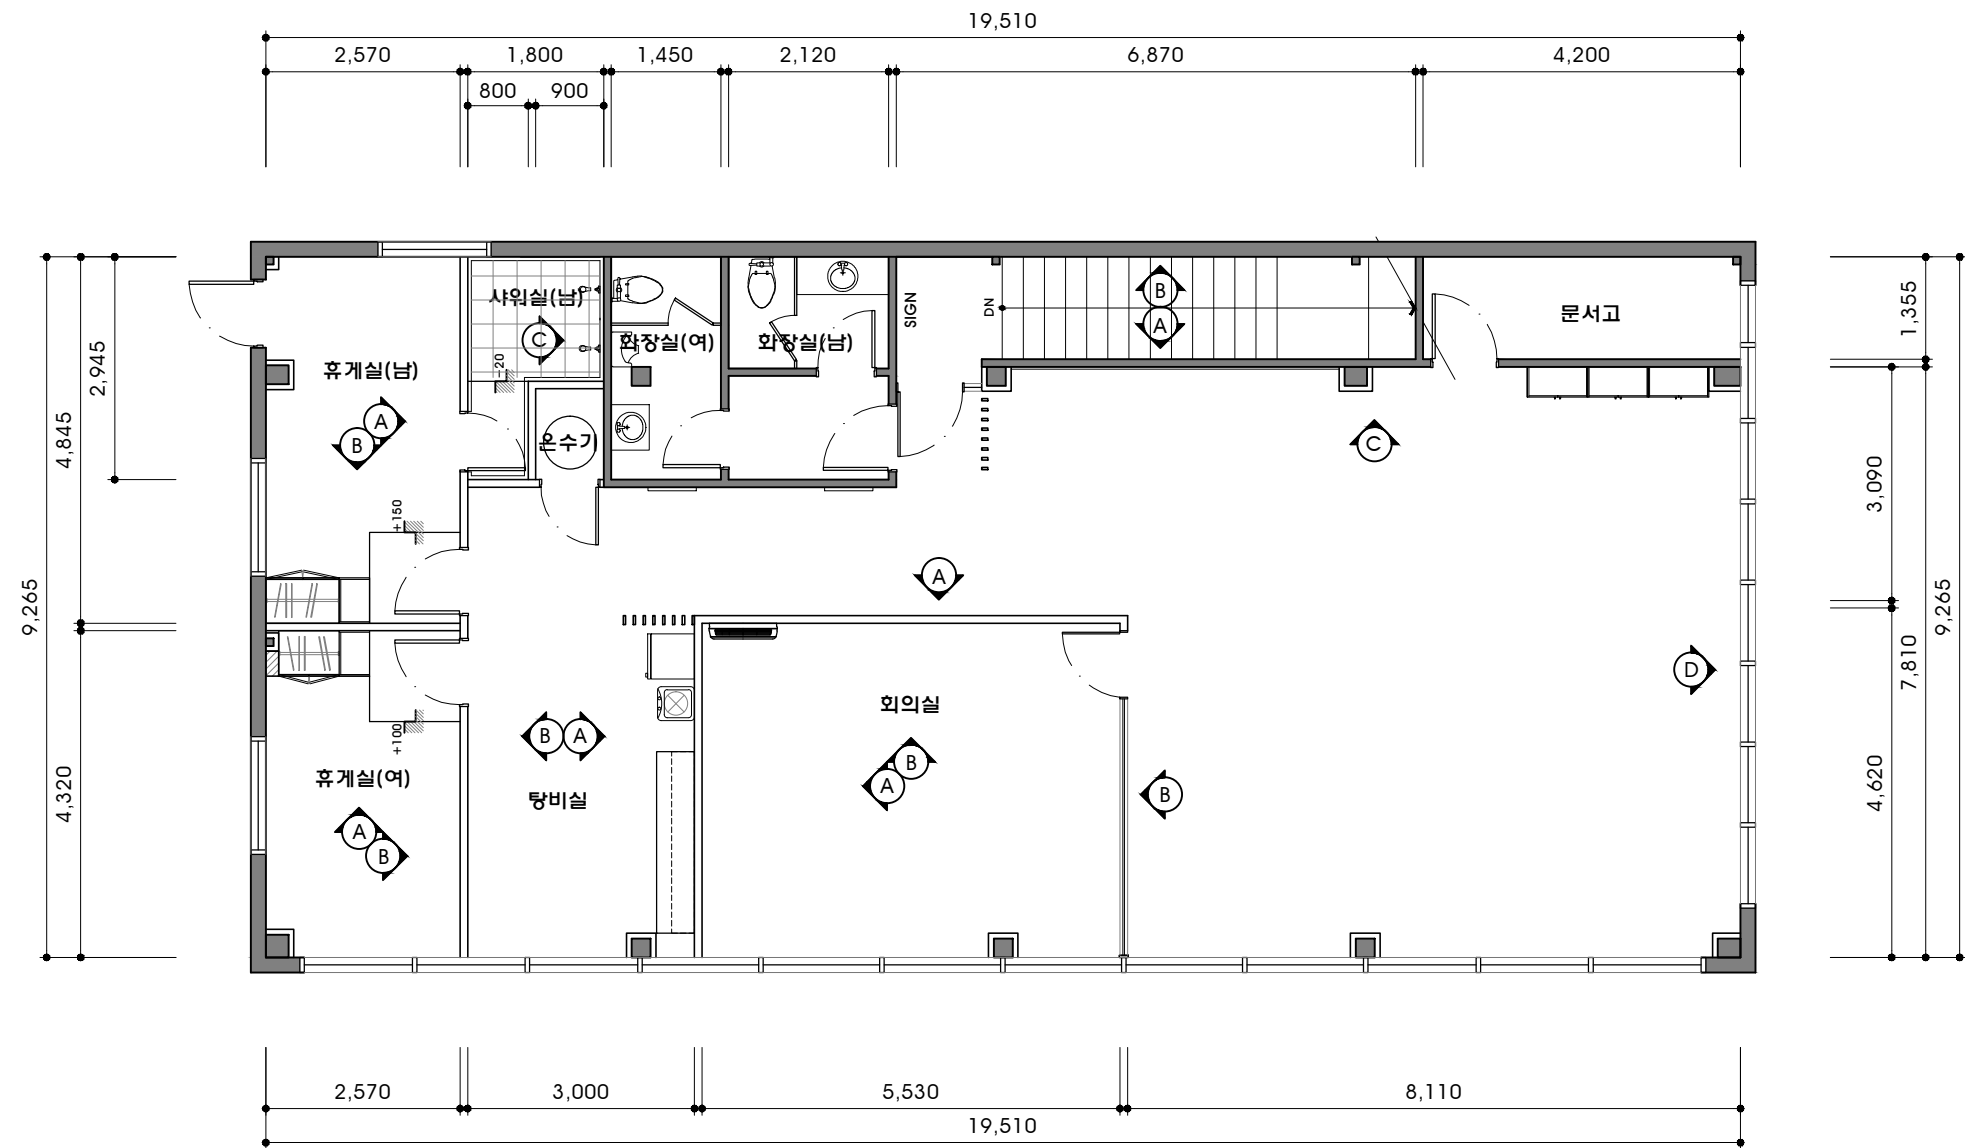

PROJECT TITLE



PROJECT

에다함 _ 대구

ARCHITECTURE DESIGN

INTERIOR ARCHITECTURE

NOTE

REF. DWG. NO.

REVISIONS

△	
△	
△	
△	
△	

KEY PLAN

DESIGNED BY

DRAWING BY

CHECKED BY

CHECKED BY

APPROVED BY

NAME OF DRAWING

KEY PLAN

SCALE

A1 : 1/100 A3 : 1/100

DATE

2017. 08

FILE NAME


DRAWING NO.

FL03


SHEET NO.

009

INTERIOR ARCHITECTURE

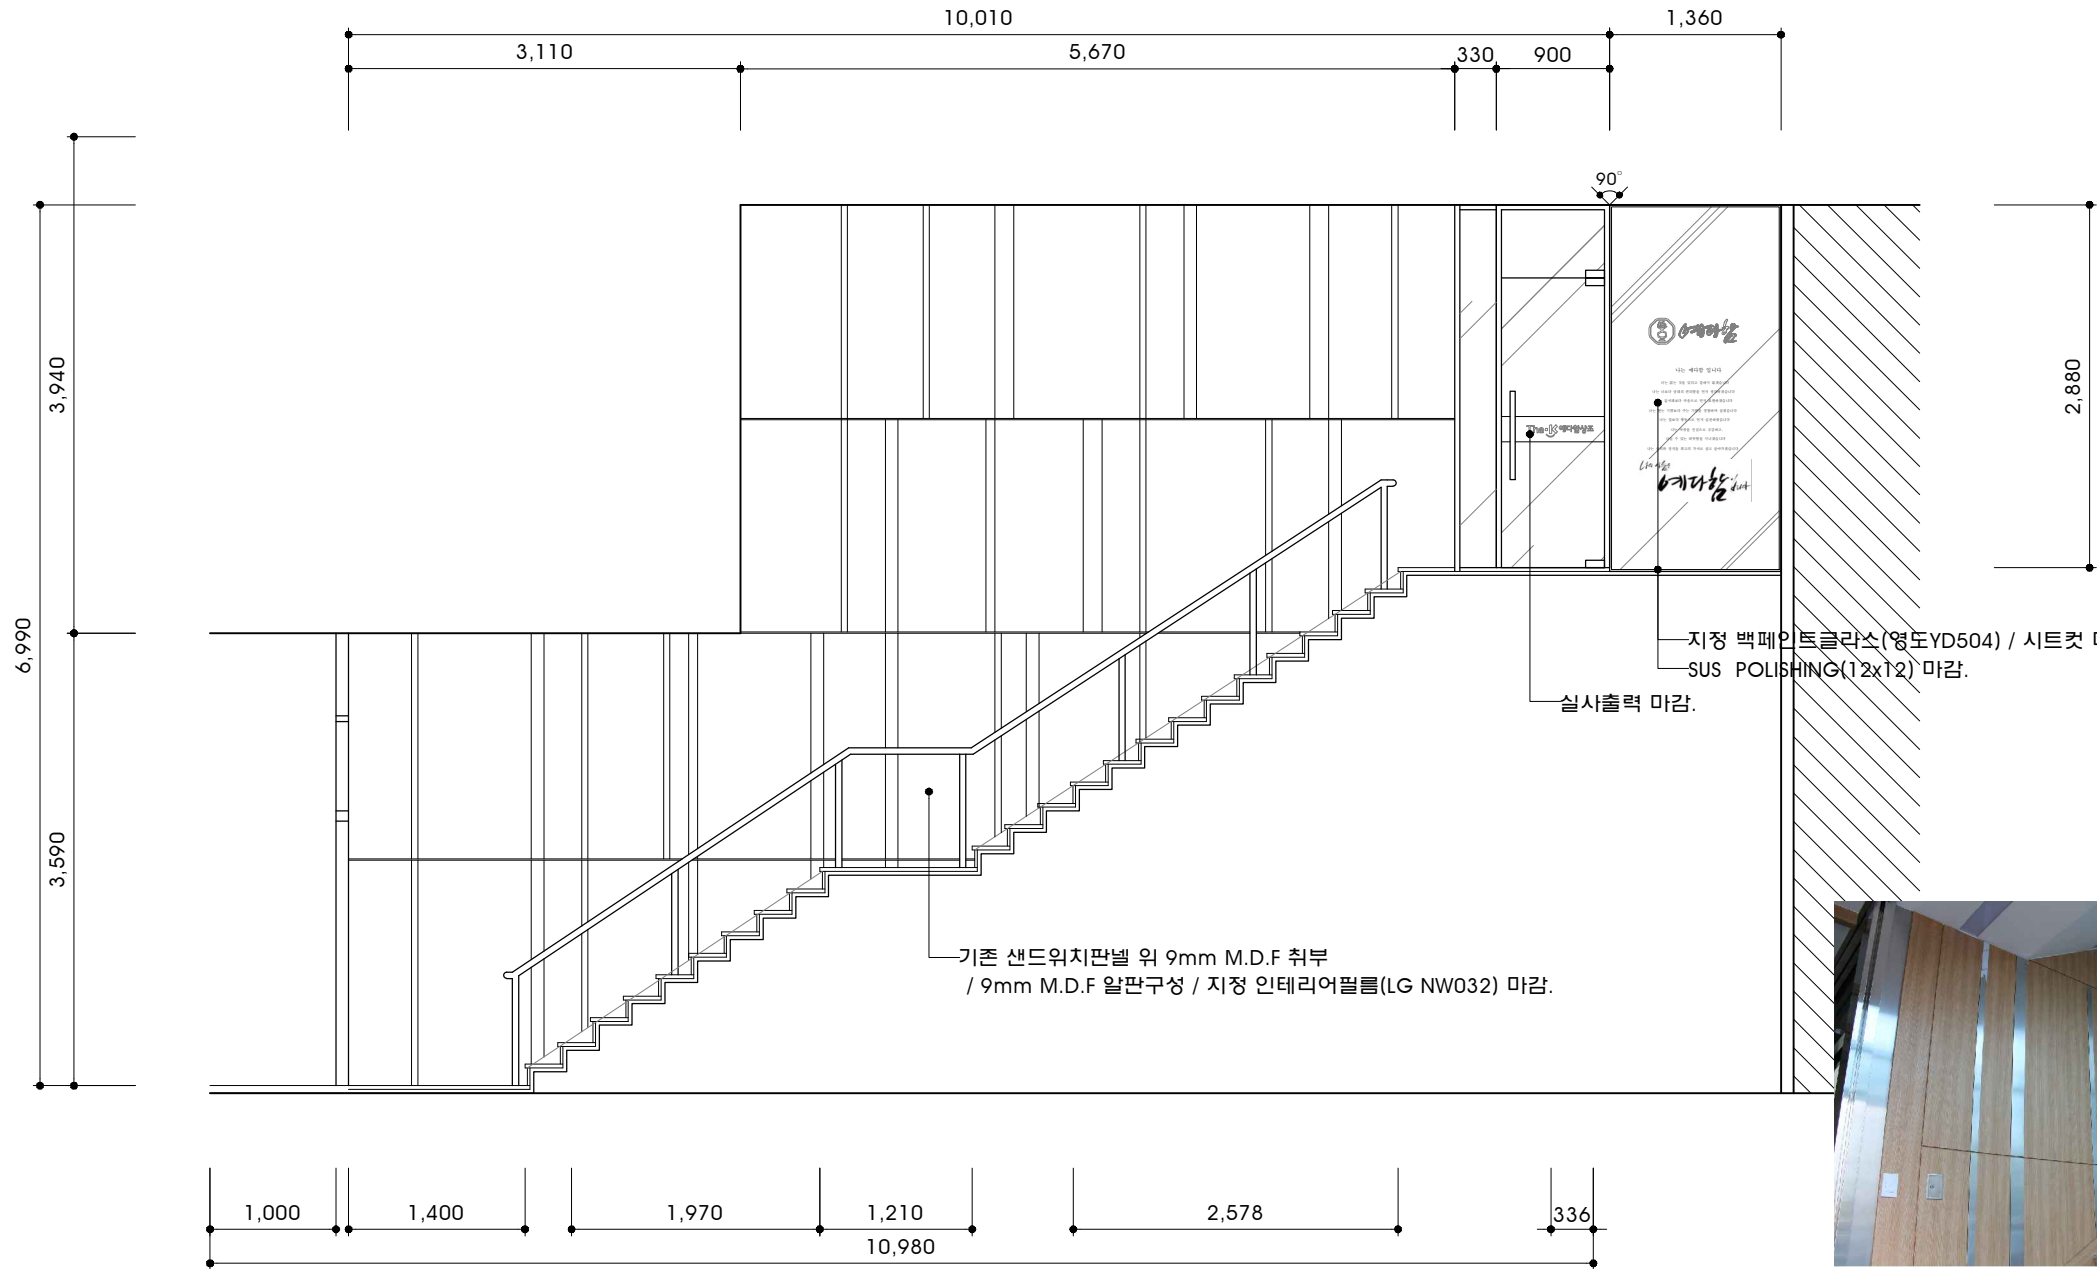

참고IMAGE

PROJECT TITLE


PROJECT
예다함 _ 대구

ARCHITECTURE DESIGN

INTERIOR ARCHITECTURE

NOTE

REF.DWG.NO.

REVISIONS

△	
△	
△	
△	
△	

KEY PLAN

DESIGNDE BY

DRAWING BY

CHECKED BY

CHECKED BY

APPROVED BY

NAME OF DRAWING
계단실
ELEVATION - A

SCALE


DATE
2017 . 08


FILE NAME


DRAWING NO.
EL - 001

SHEET NO.
010


INTERIOR ARCHITECTURE

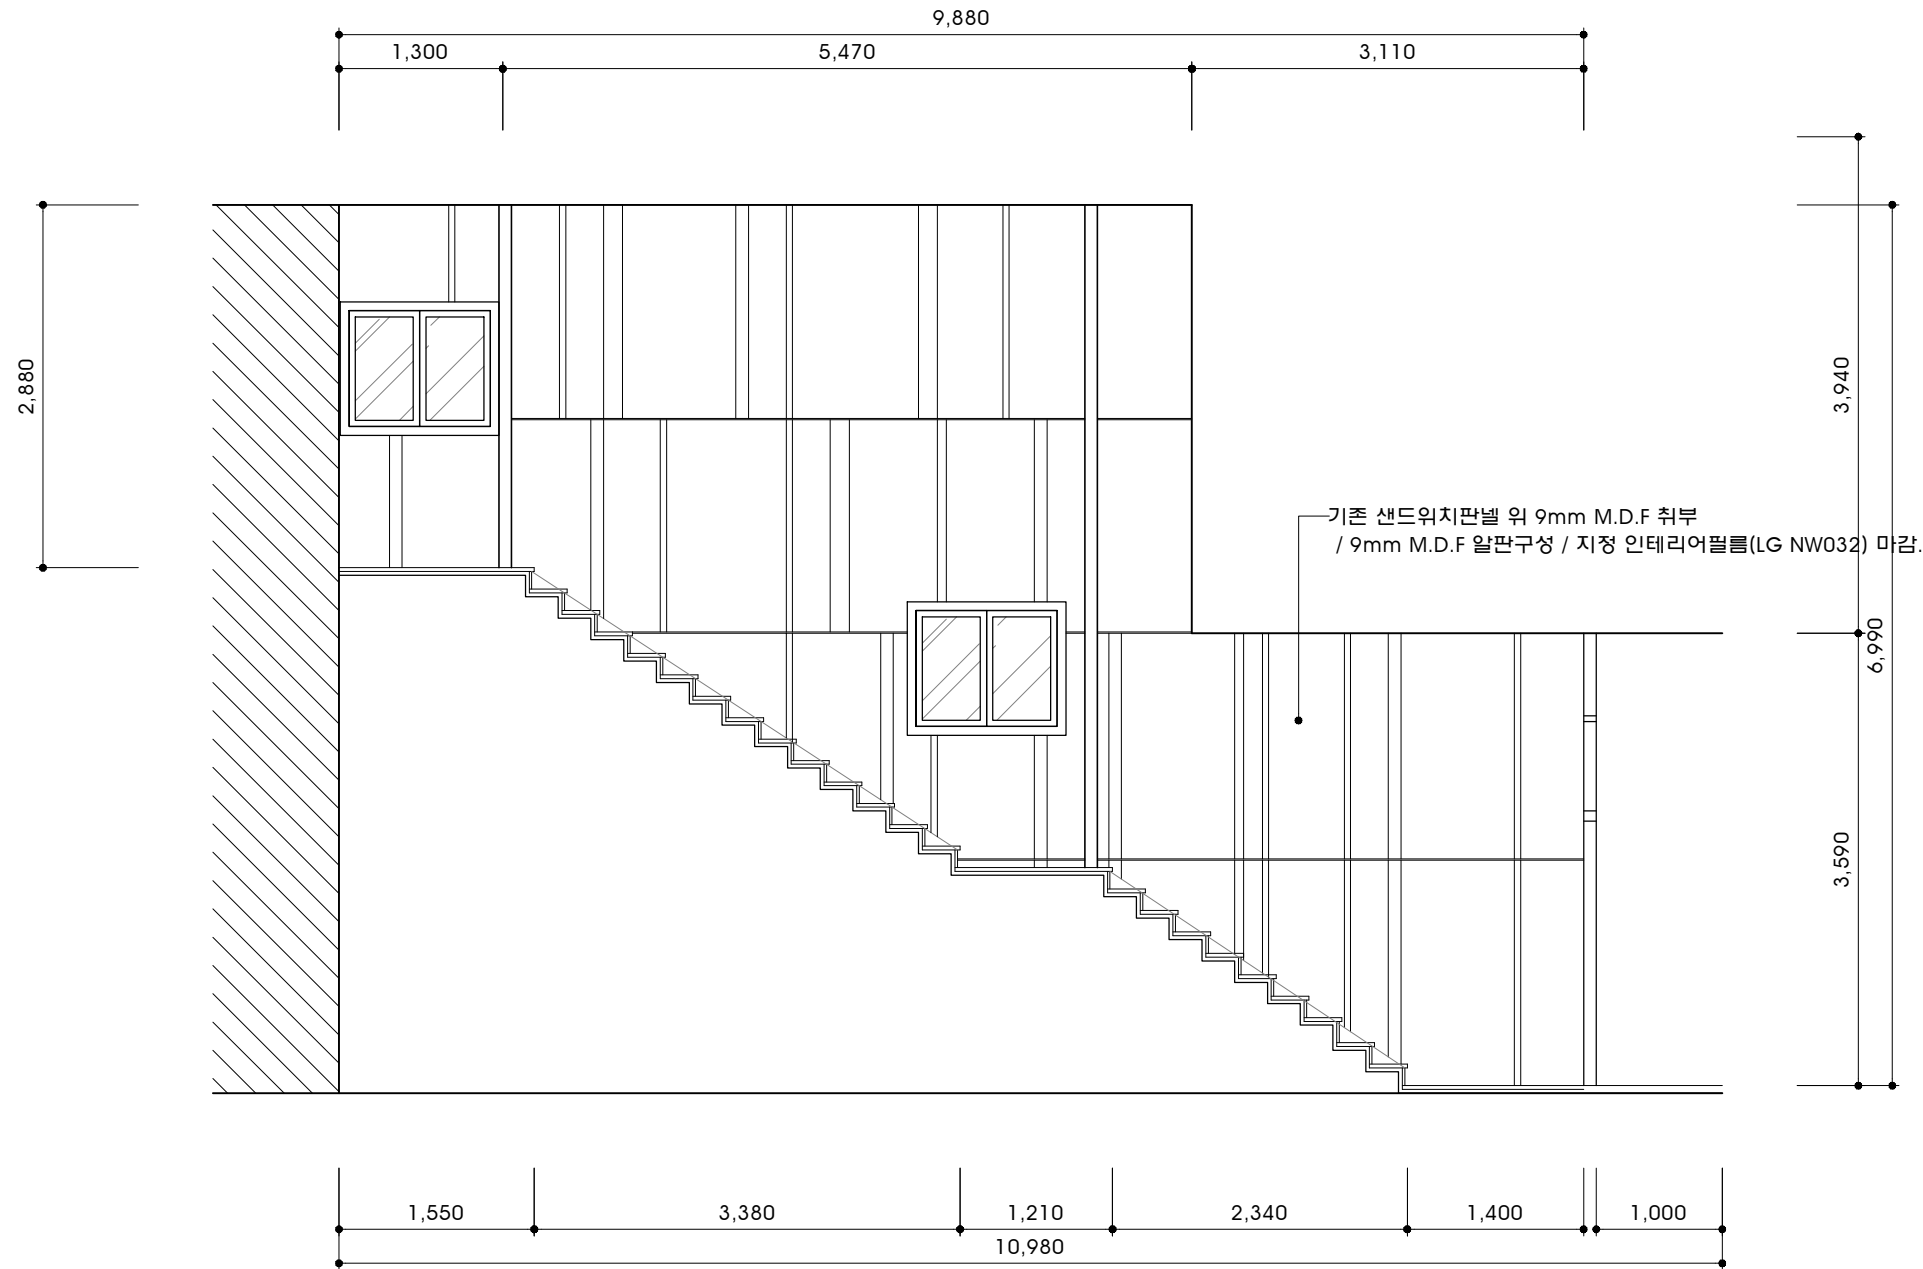

PROJECT TITLE	
<div></div>	
PROJECT	
예다함 _ 대구	
ARCHITECTURE DESIGN	
INTERIOR ARCHITECTURE	
NOTE	
REF.DWG.NO.	
REVISIONS	
△	
△	
△	
△	
△	
KEY PLAN	
DESIGNED BY	
DRAWING BY	
CHECKED BY	
CHECKED BY	
APPROVED BY	
NAME OF DRAWING	
계단실 ELEVATION - B	
SCALE	
DATE	2017. 08
FILE NAME	
DRAWING NO.	EL - 002
SHEET NO.	011
INTERIOR ARCHITECTURE	

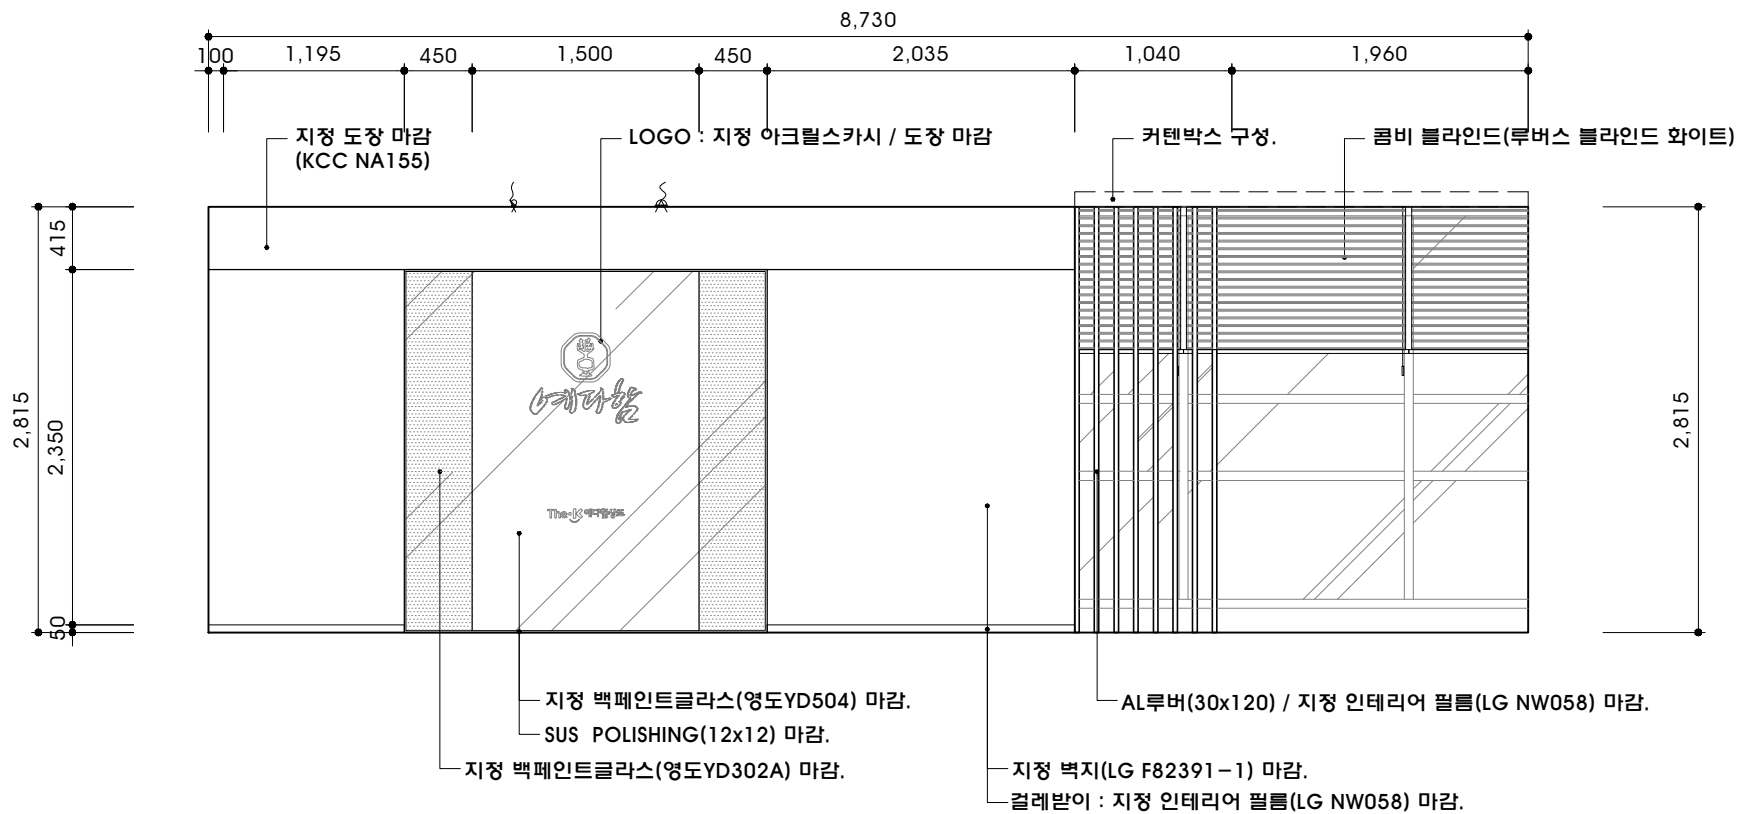

1 ELEVATION - A

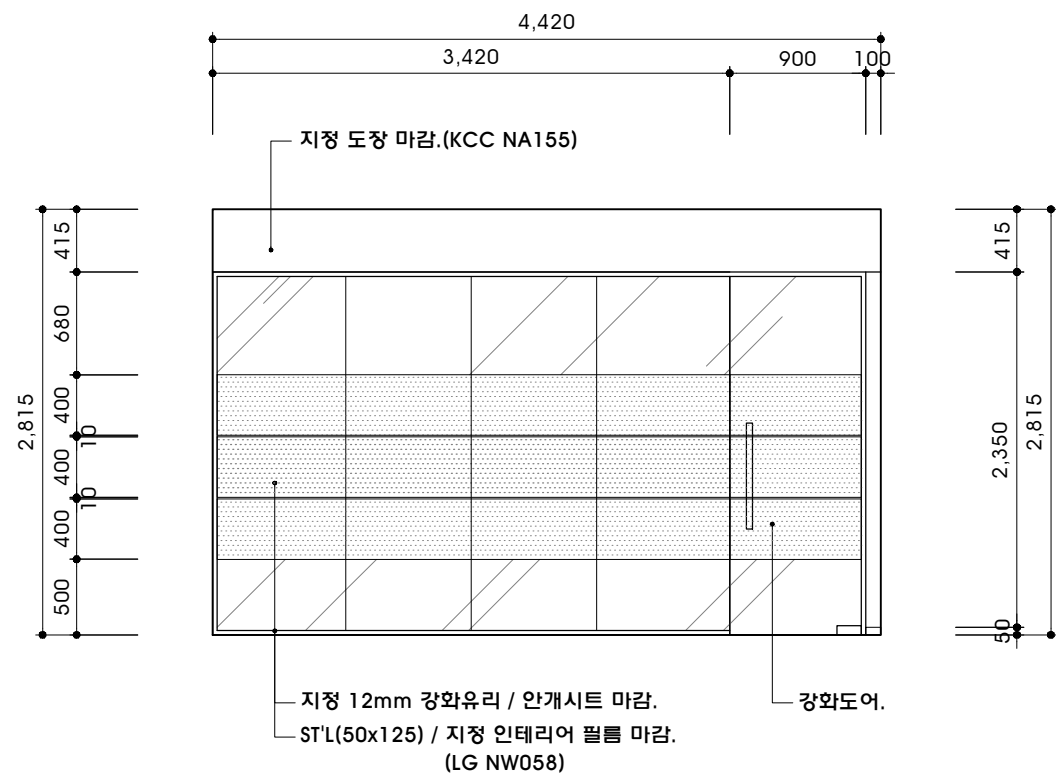

2 ELEVATION - B

PROJECT FILE



PROJECT

예다함 _ 대구

ARCHITECTURE DESIGN

 
INTERIOR ARCHITECTURE

NOTE

CH=2,815MM

REF.DWG.NO.

REVISIONS



KEY PLAN

DESIGNED BY

DRAWING BY

CHECKED BY

CHECKED BY

APPROVED BY

NAME OF DRAWING

공용공간
ELEVATION - A,B

SCALE

A3 : 1/50 A4 : 1/70

DATE

2017. 08

FILE NAME

DRAWING NO.

EL - 003


SHEET NO.

012


INTERIOR ARCHITECTURE

SCALE

A3 : 1/50 A4 : 1/70

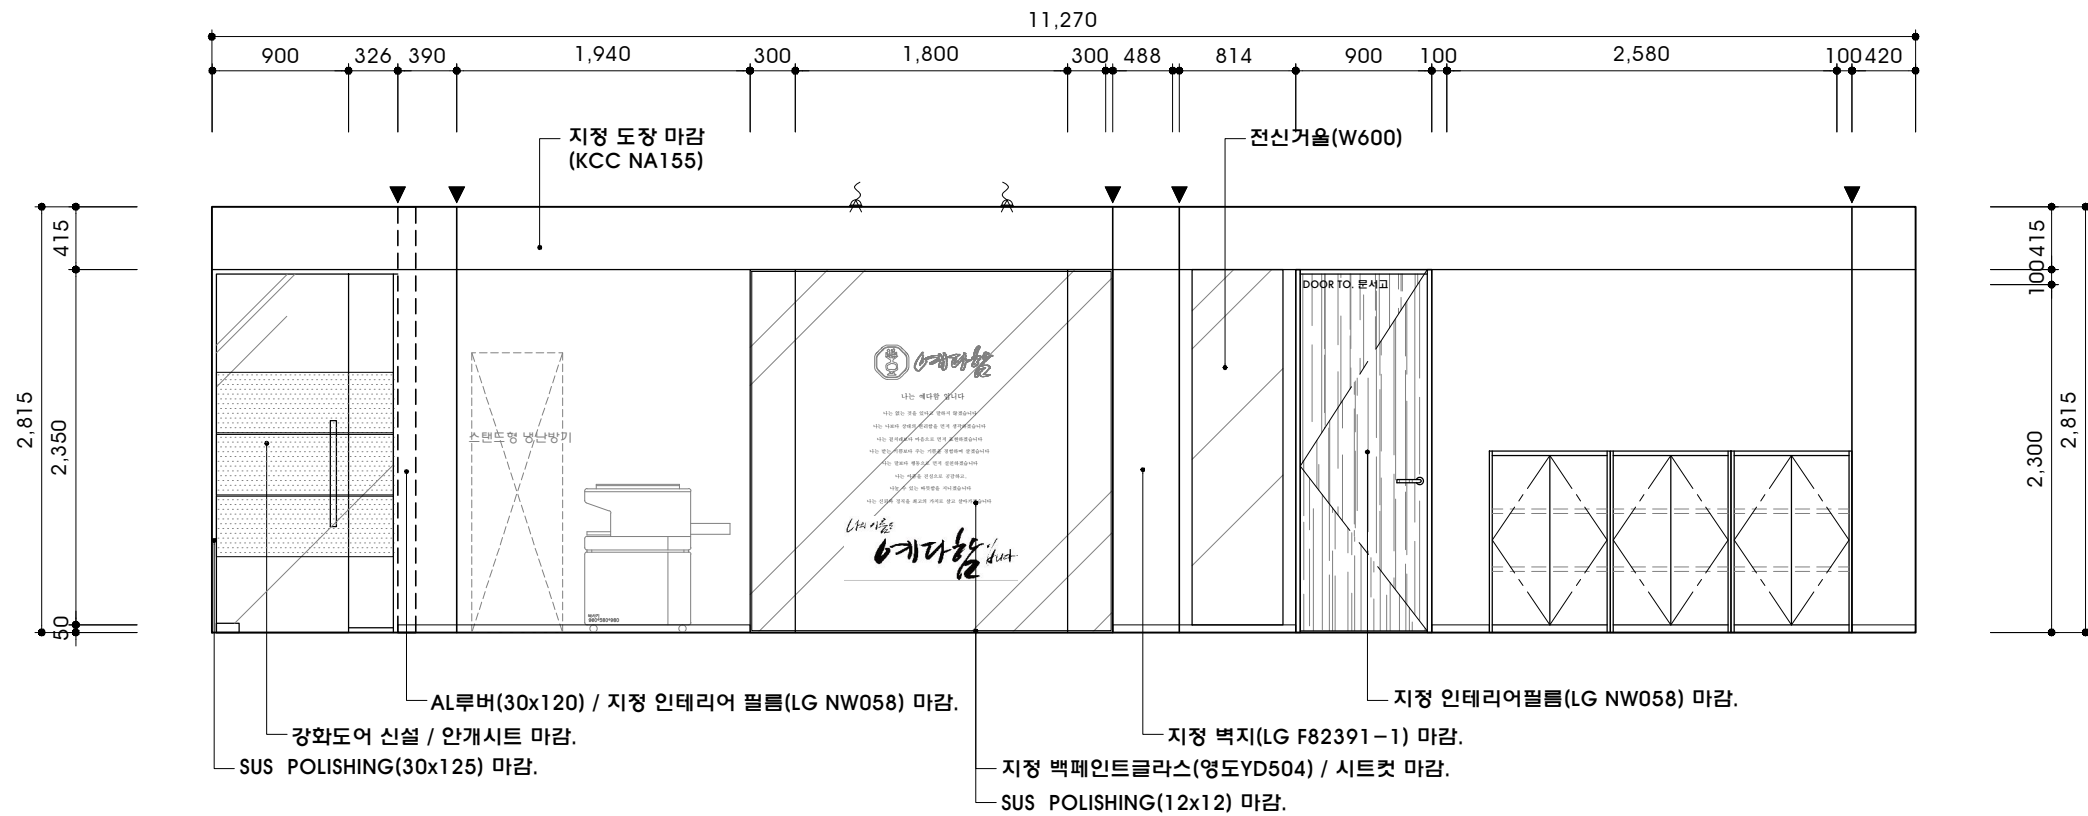

3 ELEVATION - C

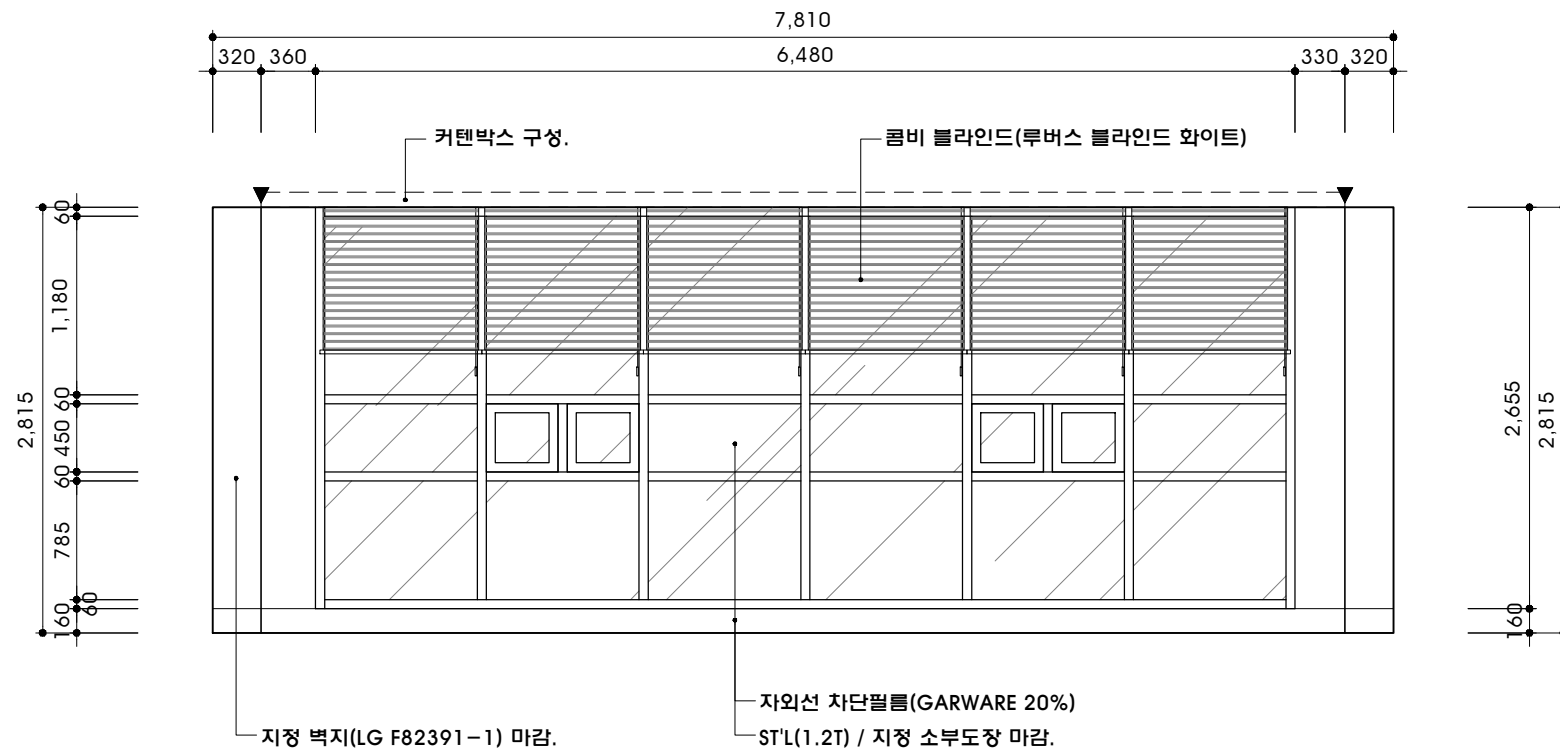

4 ELEVATION - D

PROJECT FILE



PROJECT

예다함 _ 대구

ARCHITECTURE DESIGN

 
INTERIOR ARCHITECTURE

NOTE

CH=2,815MM

REF.DWG.NO.

REVISIONS



KEY PLAN

DESIGNED BY

DRAWING BY

CHECKED BY

CHECKED BY

APPROVED BY

NAME OF DRAWING

공용공간
ELEVATION - C,D

SCALE

A3 : 1/50 A4 : 1/70

DATE

2017. 08

FILE NAME

DRAWING NO.

EL - 004


SHEET NO.

013


INTERIOR ARCHITECTURE

SCALE

A3 : 1/50 A4 : 1/70

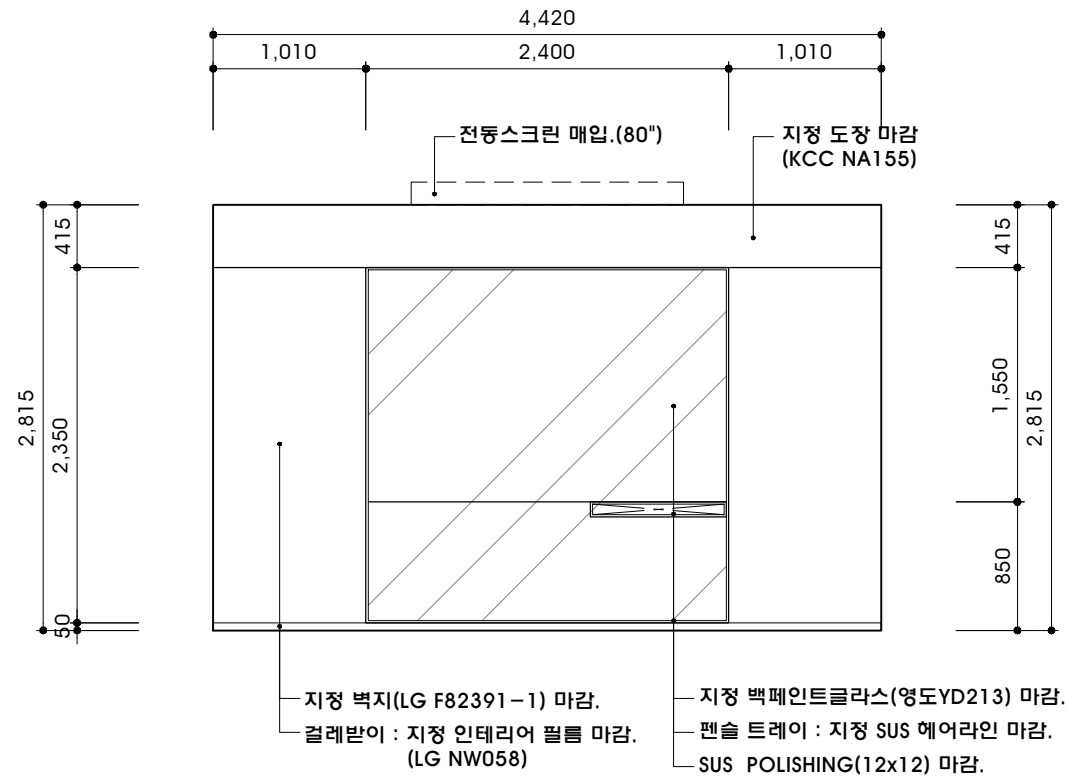

1 ELEVATION - A

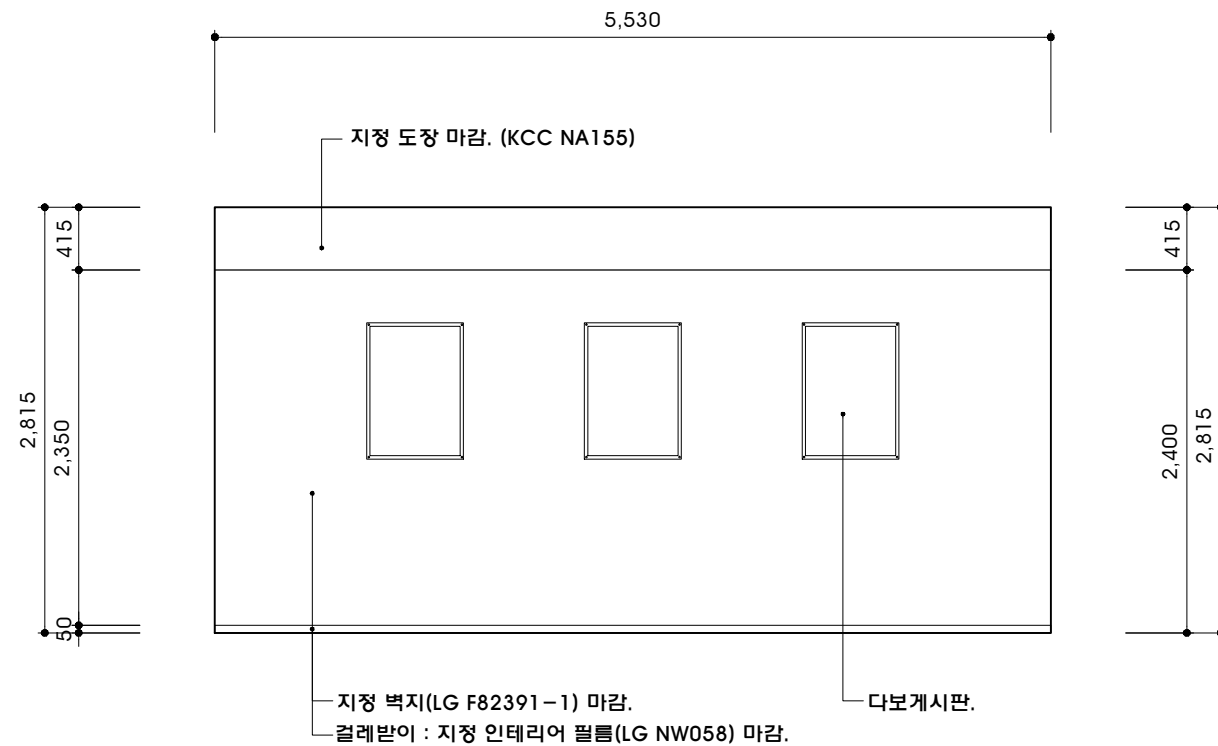

2 ELEVATION - B

PROJECT TITLE



PROJECT

예다함 _ 대구

ARCHITECTURE DESIGN

INTERIOR ARCHITECTURE

NOTE

CH=2,815MM

REF.DWG.NO.

REVISIONS

△	
△	
△	
△	
△	

KEY PLAN

DESIGNED BY

DRAWING BY

CHECKED BY

CHECKED BY

APPROVED BY

NAME OF DRAWING

회의실
ELEVATION - A,B

SCALE

A3 : 1/50 A4 : 1/70

DATE

2017. 08

FILE NAME

DRAWING NO.

EL - 005

SHEET NO.


014

INTERIOR ARCHITECTURE


SCALE

A3 : 1/50 A4 : 1/70

1 ELEVATION – A

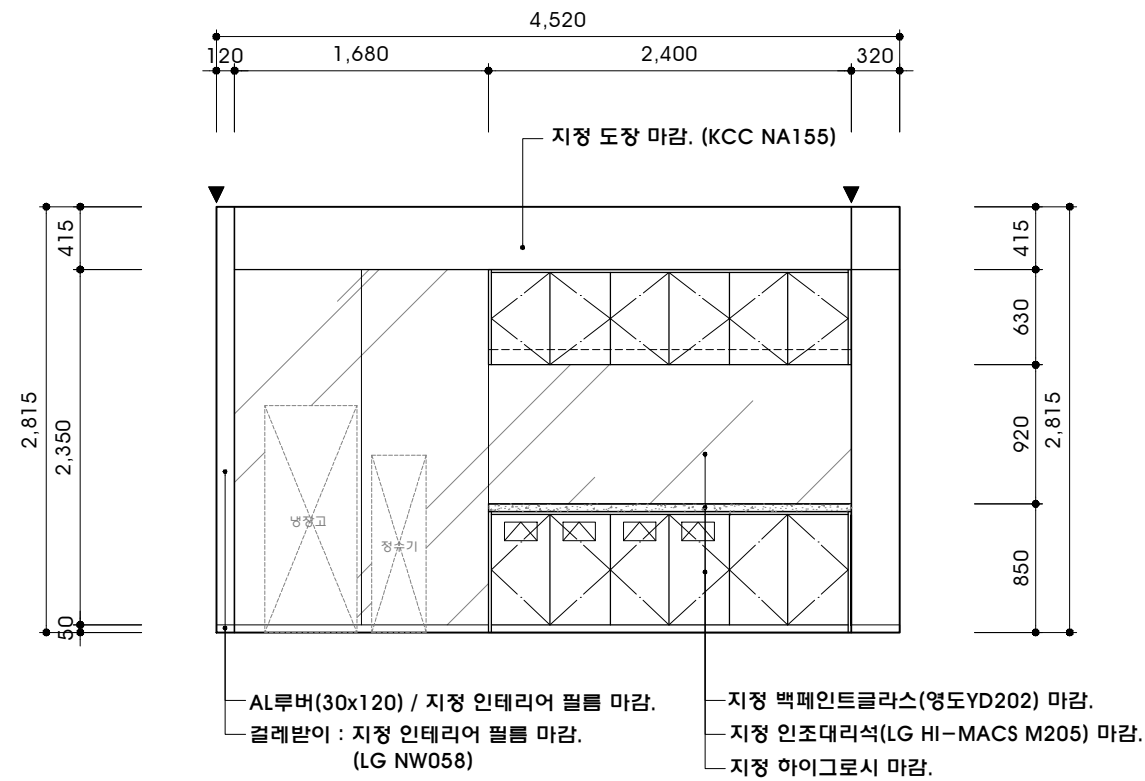

2 ELEVATION – B

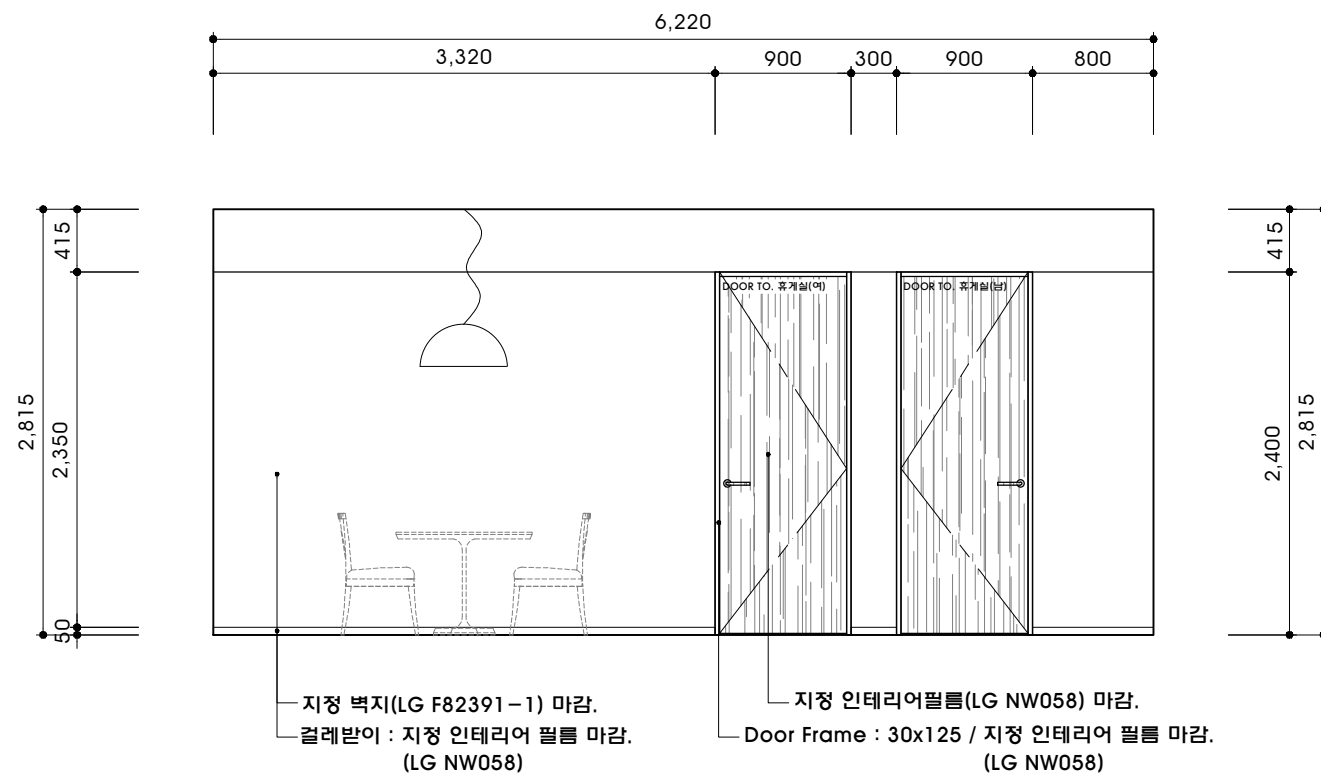

PROJECT TITLE



PROJECT

예담함 _ 대구

ARCHITECTURE DESIGN

 
INTERIOR ARCHITECTURE

NOTE

CH=2,815MM

REF.DWG.NO.

REVISIONS



KEY PLAN

DESIGNED BY

DRAWING BY

CHECKED BY

CHECKED BY

APPROVED BY

NAME OF DRAWING

탕비실
ELEVATION – A,B

SCALE

A3 : 1/50 A4 : 1/70

DATE

2017. 08

FILE NAME

DRAWING NO.

EL - 006



SHEET NO.

015

INTERIOR ARCHITECTURE


SCALE

A3 : 1/50 A4 : 1/70

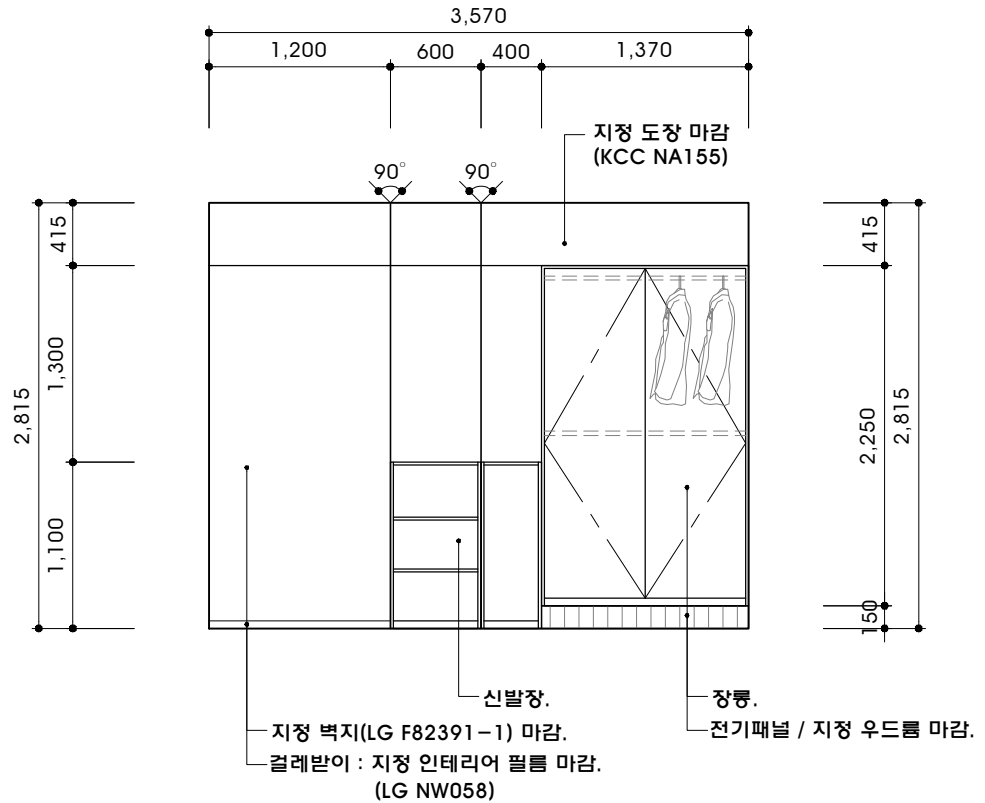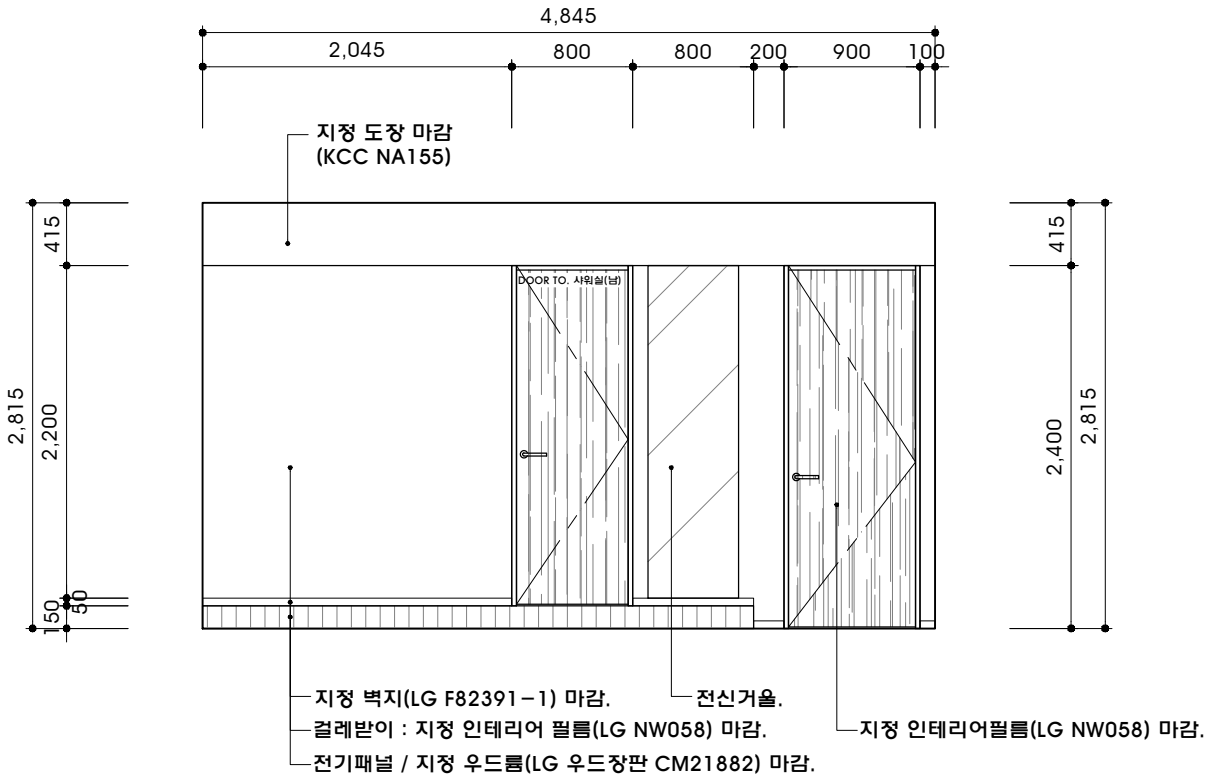


1 ELEVATION - A

2 ELEVATION - B

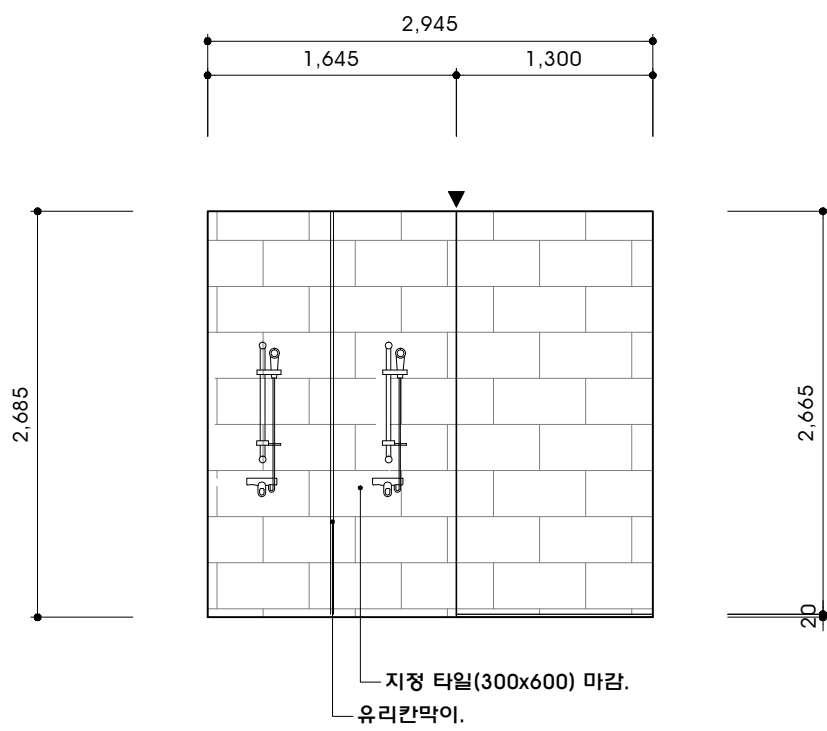

3 ELEVATION - C

PROJECT TITLE


PROJECT
예담함 _ 대구

ARCHITECTURE DESIGN

INTERIOR ARCHITECTURE

NOTE
CH=2,815MM

REF.DWG.NO.

REVISIONS

△	
△	
△	
△	

KEY PLAN

DESIGNDE BY

DRAWING BY

CHECKED BY

CHECKED BY

APPROVED BY

NAME OF DRAWING
휴게실(남)
ELEVATION - A,B,C

SCALE
A3 : 1/50 A4 : 1/70

DATE
2017. 08



FILE NAME

DRAWING NO.
EL - 007

SHEET NO.
016

INTERIOR ARCHITECTURE

SCALE
A3 : 1/50 A4 : 1/70

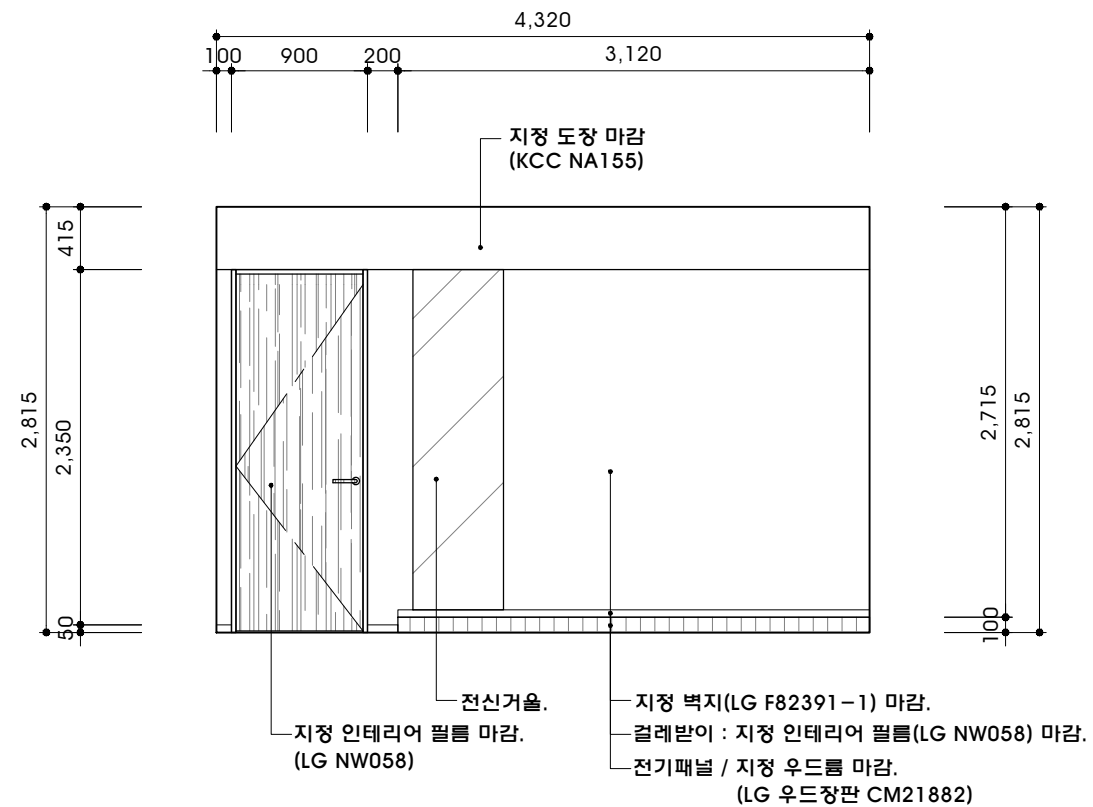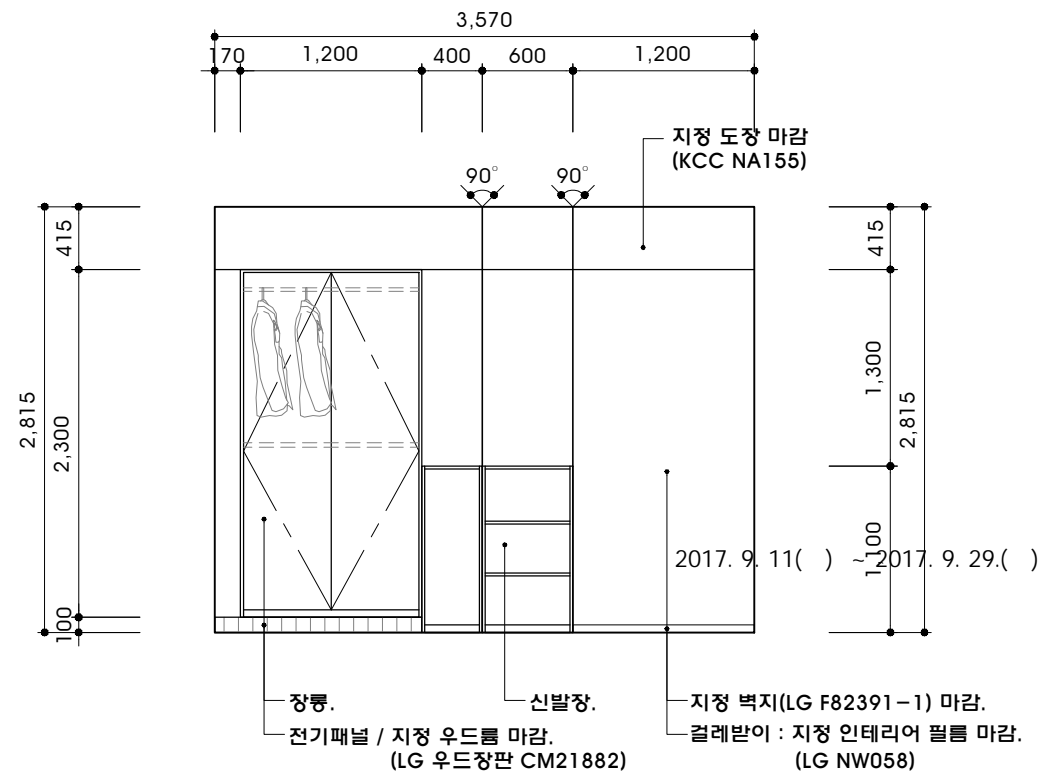

1 ELEVATION - A

2 ELEVATION - B

PROJECT FILE



PROJECT

예다함 _ 대구

ARCHITECTURE DESIGN

INTERIOR ARCHITECTURE

NOTE

CH=2,815MM

REF.DWG.NO.

REVISIONS

△	
△	
△	
△	
△	

KEY PLAN

DESIGNER BY

DRAWING BY

CHECKED BY

CHECKED BY

APPROVED BY

NAME OF DRAWING

휴게실(여)
ELEVATION - A,B

SCALE

A3 : 1/50 A4 : 1/70

DATE

2017. 08

FILE NAME

DRAWING NO.

EL - 008

SHEET NO.

017

INTERIOR ARCHITECTURE

SCALE

A3 : 1/50 A4 : 1/70